

1

2


3

4

EXTERIOR MATERIAL SCHEDULE							
#	DESCRIPTION	MANUFACTURER	TYPE/STYLE	COLOR	HEIGHT	WIDTH	COMMENTS
1							

D

C

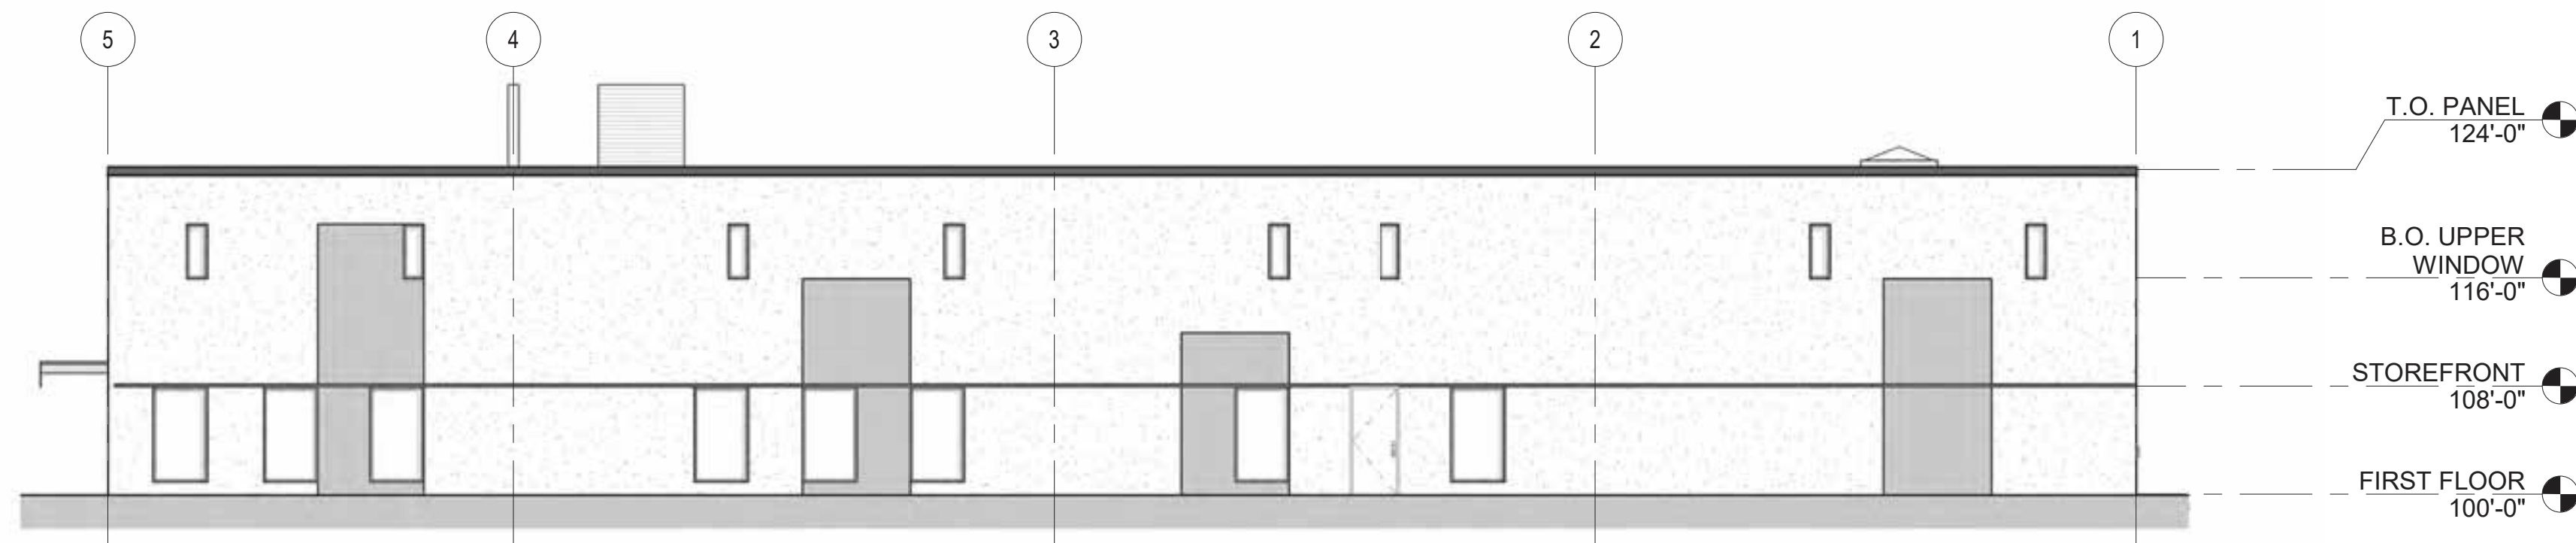


C1 NORTH ELEVATION
3/32" = 1'-0"

B



B1 NORTHWEST ELEVATION
3/32" = 1'-0"

A

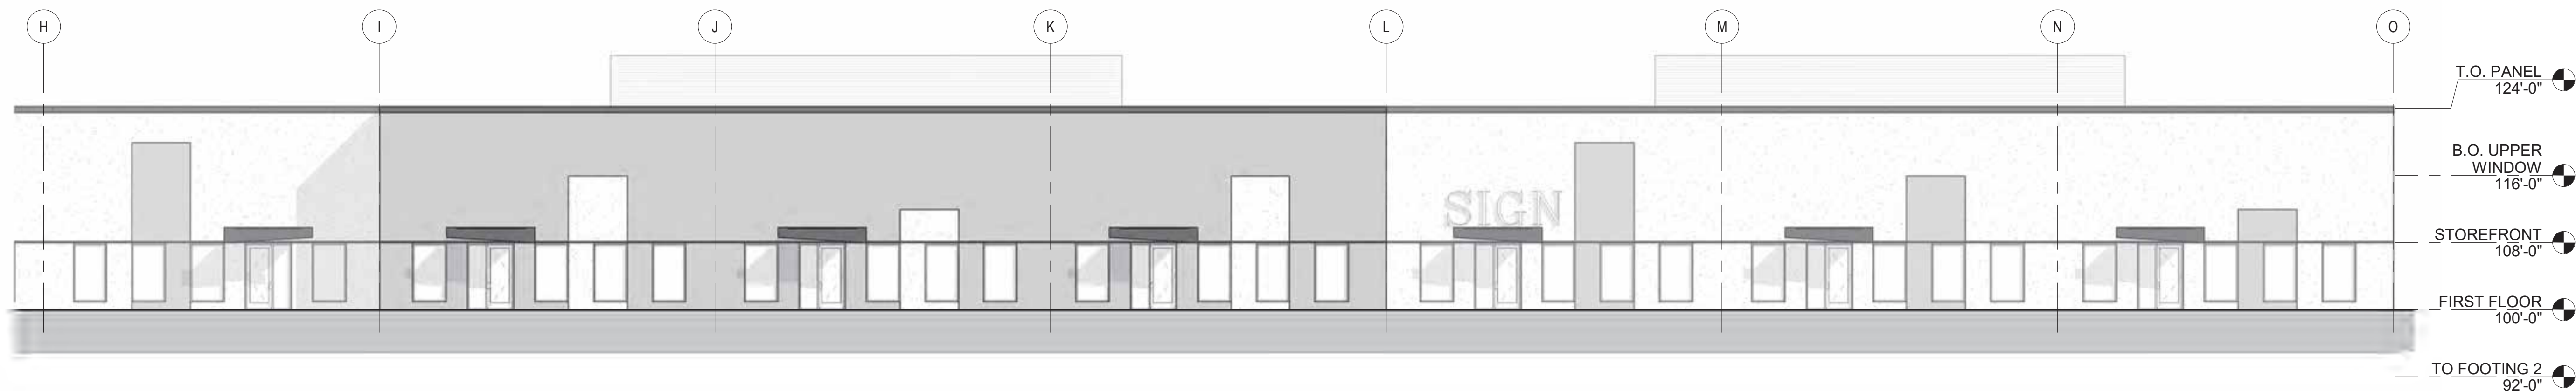

A1 NORTHEAST ELEVATION
3/32" = 1'-0"

FGC FLEX BUILDING
NEW CONSTRUCTION
4921 FEMRITE DR.
MADISON, WI 53716

Project Status

11/25/2020 UDC REVIEW

PROJ. #: 20001-01

© SKETCHWORKS ARCHITECTURE 2020

EXTERIOR ELEVATIONS

A201

PRELIMINARY


EXTERIOR MATERIAL SCHEDULE							
#	DESCRIPTION	MANUFACTURER	TYPE/STYLE	COLOR	HEIGHT	WIDTH	COMMENTS
1							

D


C

B


A

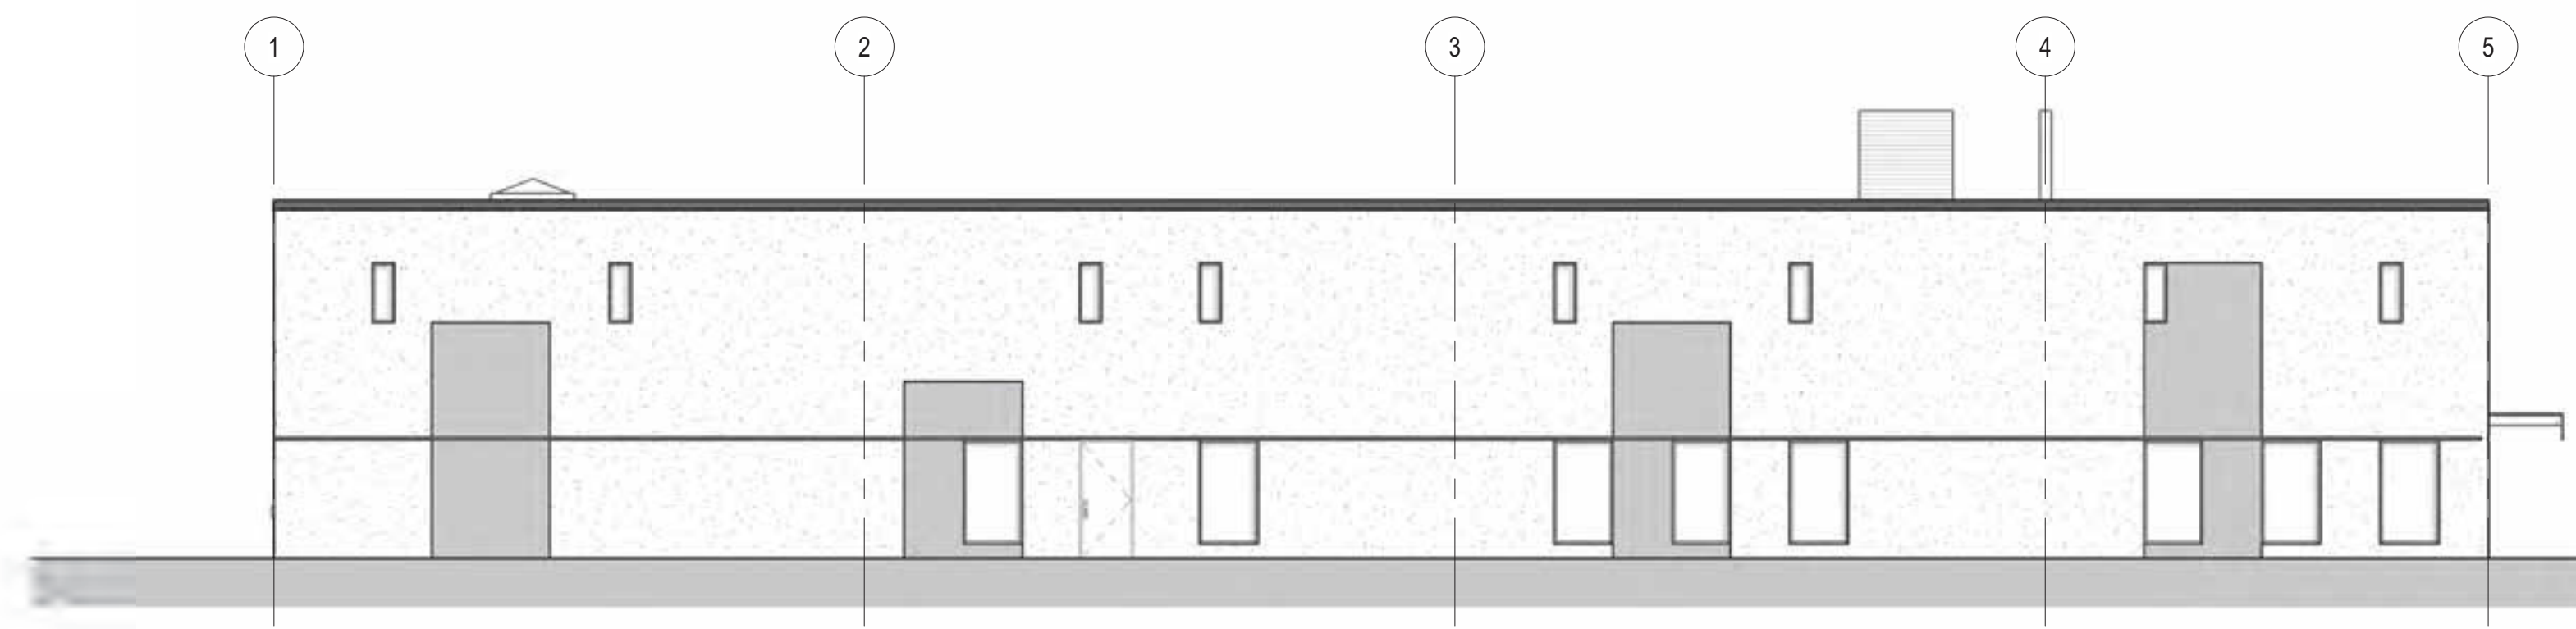

C1 SOUTH ELEVATION
3/32" = 1'-0"

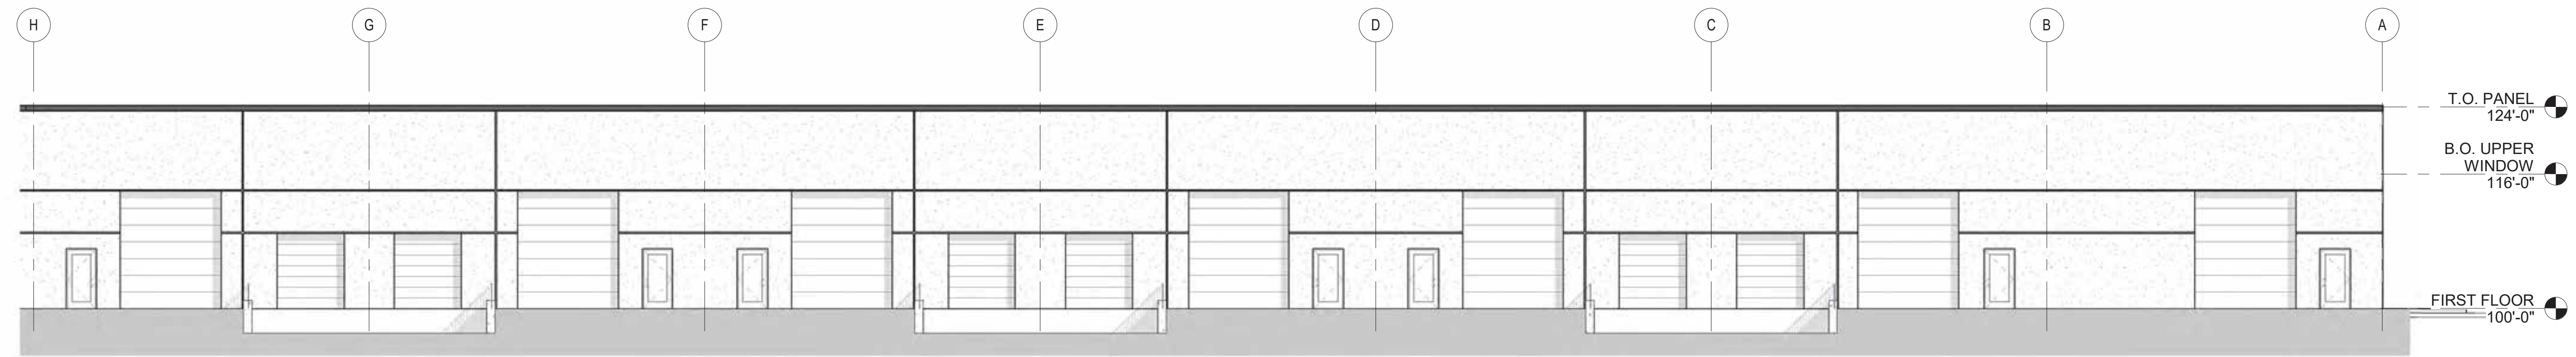

B1 SOUTHWEST ELEVATION
3/32" = 1'-0"

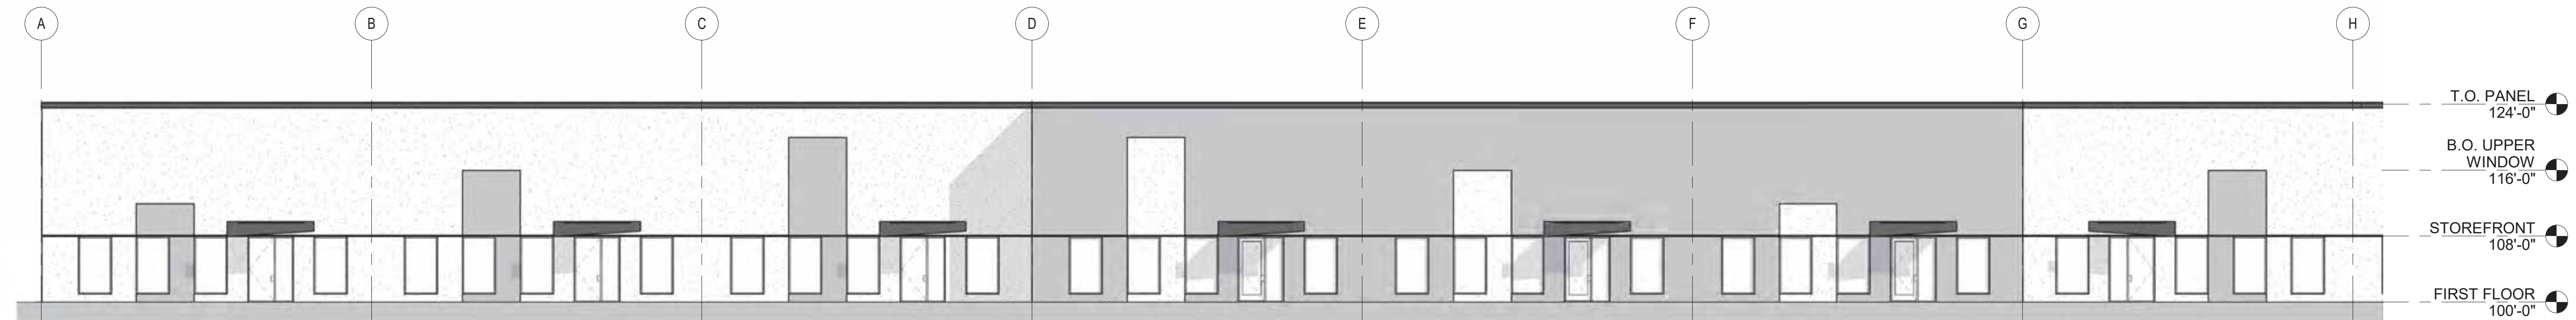

A1 SOUTHEAST ELEVATION
3/32" = 1'-0"

FGC FLEX BUILDING
NEW CONSTRUCTION
4921 FEMRITE DR.
MADISON, WI 53716

Project Status

DATE	DESCRIPTION

PROJ. #: 20001-01

© SKETCHWORKS ARCHITECTURE 2020

EXTERIOR ELEVATIONS

PRELIMINARY

A202

D



SOUTHEAST VIEW



SOUTH VIEW



NORTHEAST VIEW

C



ENTRY VIEW



NORTHEAST CORNER



NORTH (TRADEWINDS)

B



MAIN FRONTAGE VIEW



LOADING DOCK VIEW

A

FGC FLEX BUILDING

NEW CONSTRUCTION
4921 FEMRITE DR.
MADISON, WI 53716

Project Status

11/25/2020 UDC REVIEW

PROJ. #: 20001-01

© SKETCHWORKS
ARCHITECTURE 2020

BUILDING 3D

A901

PRELIMINARY


A B C D

1

2

3

4

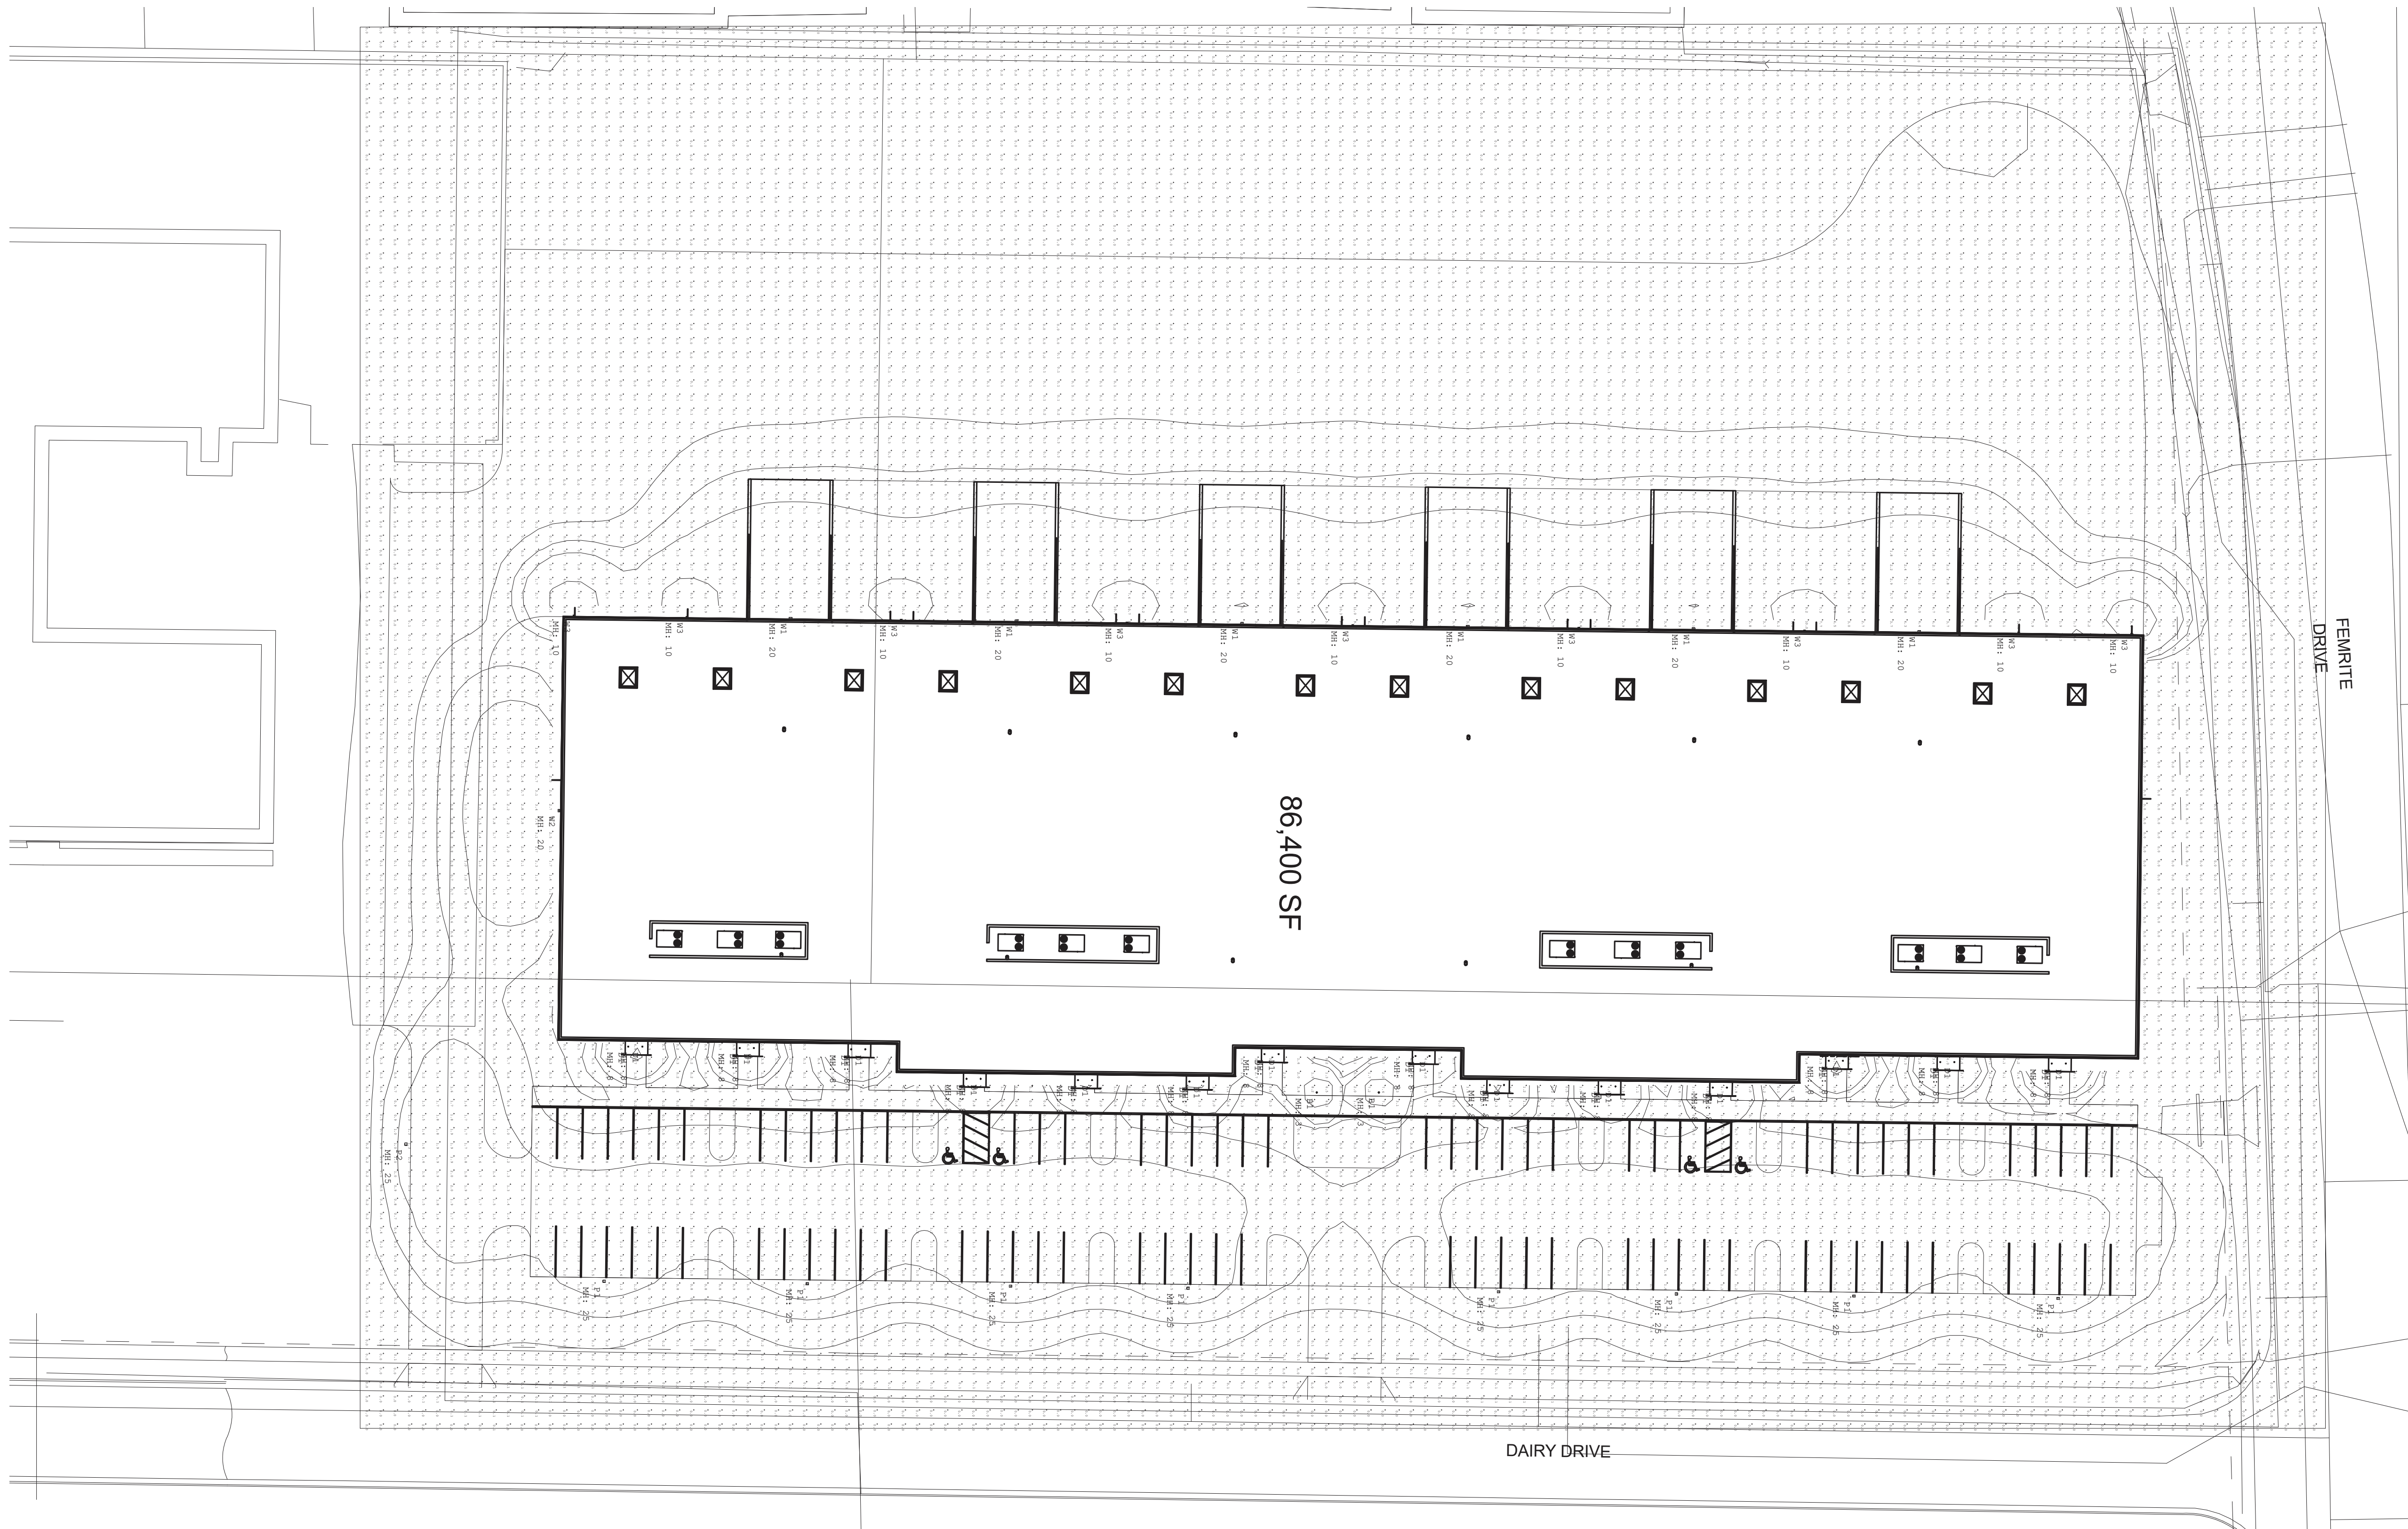

A1 SITE LIGHTING PLAN
NOT TO SCALE

FGC FLEX BUILDING
NEW CONSTRUCTION
4921 FEMRITE DR.
MADISON, WI 53716

Project Status
11/25/2020 UDC REVIEW

PROJ. #: 20001-01

© SKETCHWORKS
ARCHITECTURE 2020

**SITE LIGHTING
PLAN**

ES101

PRELIMINARY