




## First Floor Plan

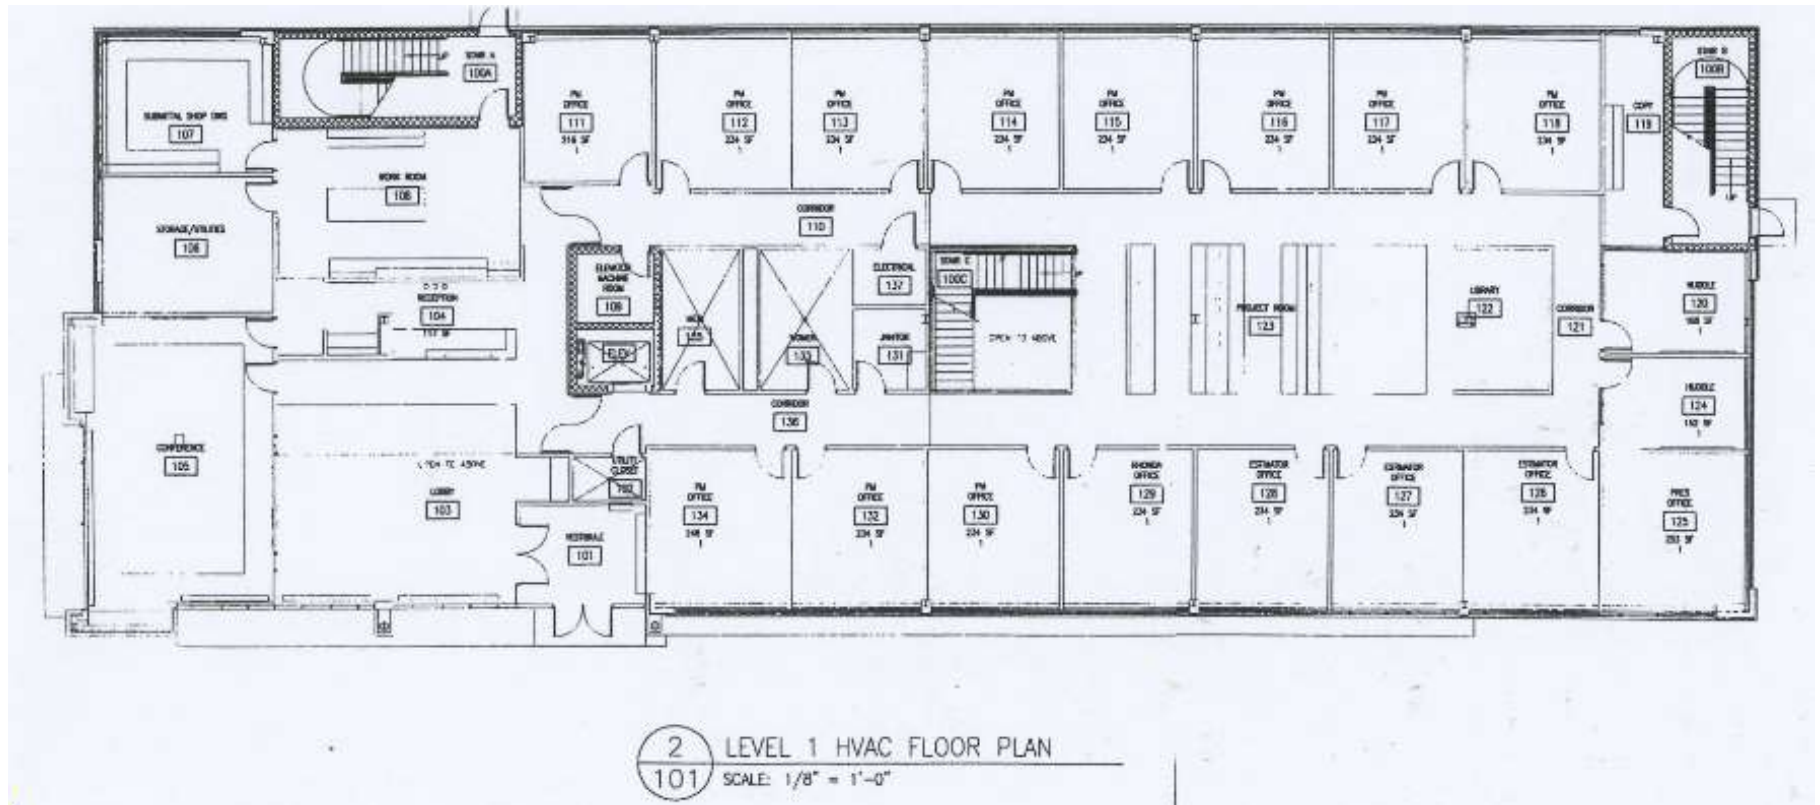

## Second Floor Plan

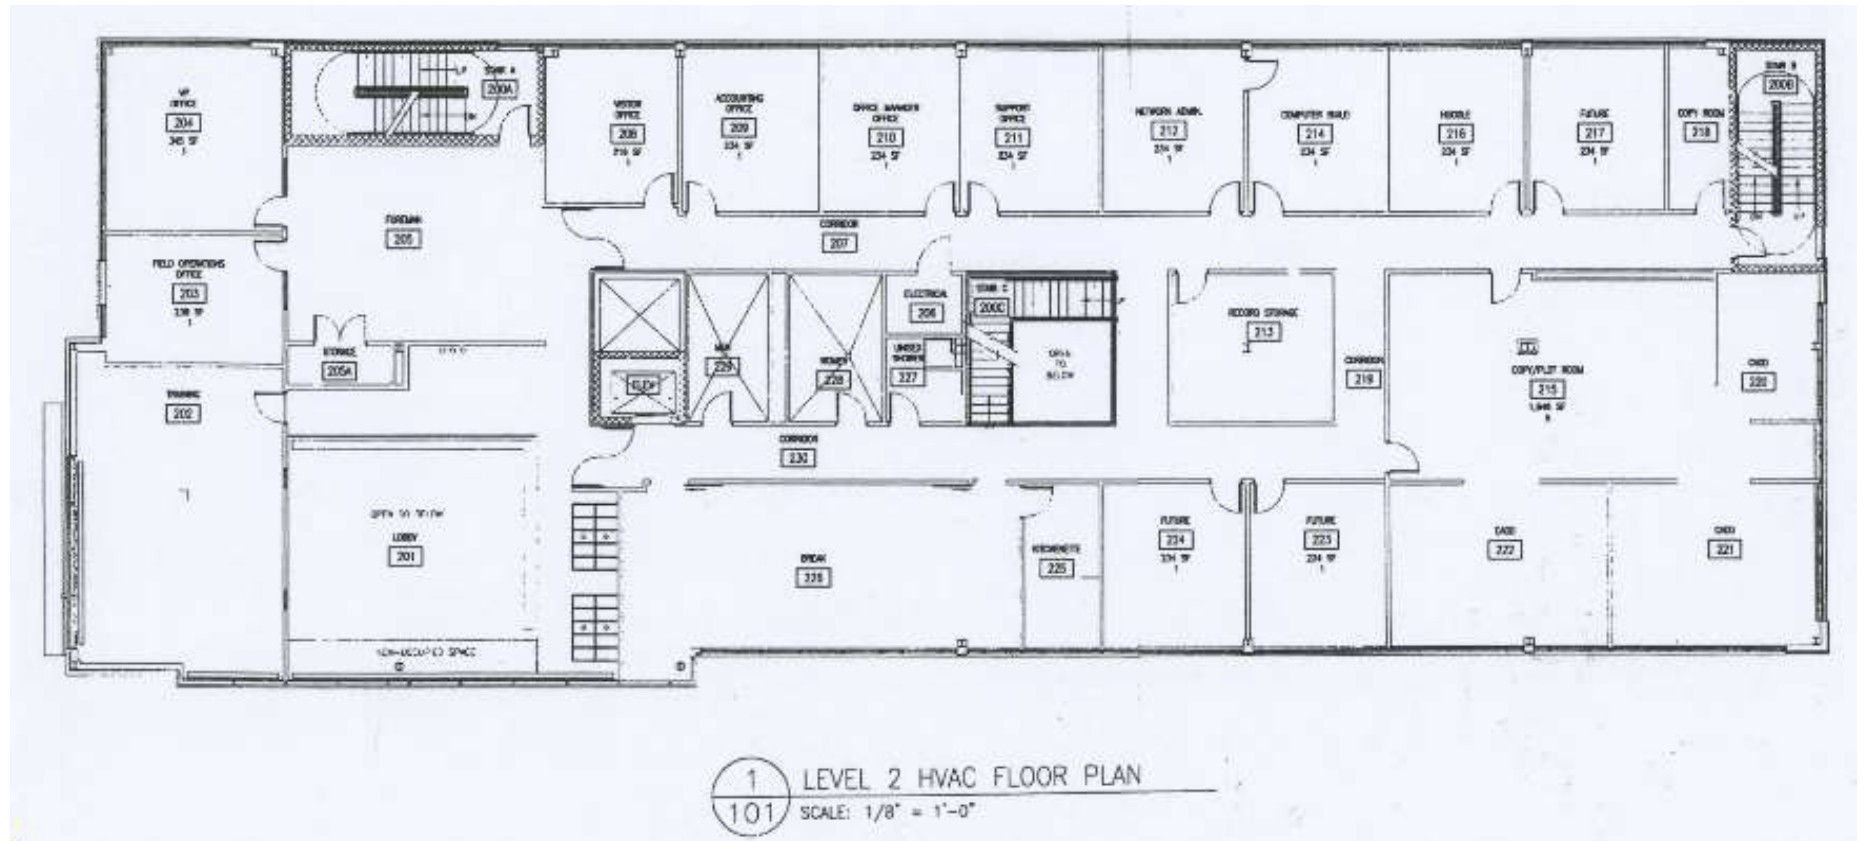

### Third Floor Plan

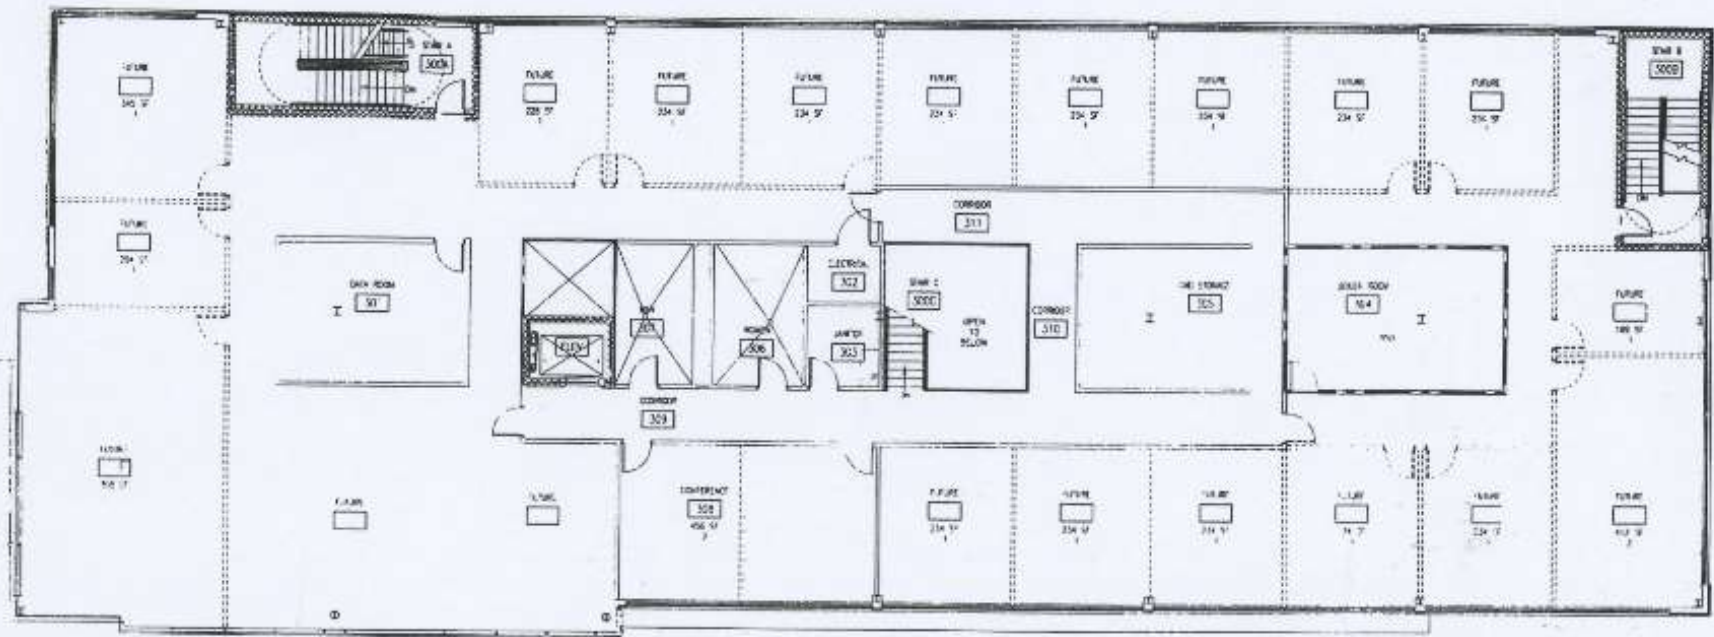

2 LEVEL 3 HVAC FLOOR PLAN  
102 SCALE: 1/8" = 1'-0"