

STATE BANK OF CROSS PLAINS


COUNTY TRUNK HIGHWAY "M" MADISON, WISCONSIN

MAYO corporation
ENGINEERS SURVEYORS ARCHITECTS PLANNERS
600 GRAND CANYON DRIVE, MADISON, WI 53719-1044
PHONE (608) 833-0628 FAX (608) 833-0746
E-MAIL MAYO@MAYOENGINEERS.COM



BUILDING CONSTRUCTION INC.

P.O. BOX 620151
MIDDLETON, WI 53562-0151
(608) 831-0011
FAX (608) 836-6817

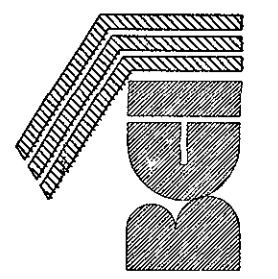

OWNER
STATE BANK OF CROSS PLAINS
PROJECT
STATE BANK OF CROSS PLAINS
COUNTY HWY "M"
MADISON, WISCONSIN

INITIALS
FILE
03-22-00
SCALE AS SHOWN
BI-03-00
SHEET NO.
1

DRAWING INDEX

GENERAL

T-1 TITLE SHEET

SITE

- C-1 CERTIFIED SURVEY MAP
- C-2 ARCHITECTURAL SITE PLAN
- C-3 GRADING AND EROSION CONTROL SITE PLAN
- C-4 LANDSCAPING SITE PLAN
- C-5 SITE LIGHTING PLAN
- C-6 SITE UTILITY PLAN

STRUCTURAL

- S-1 FIRST FLOOR FRAMING PLAN
- S-2 SECOND FLOOR FRAMING PLAN
- S-3 ROOF FRAMING PLAN

ARCHITECTURAL

- A-1 BASEMENT FLOOR PLAN
- A-2 FIRST FLOOR PLAN
- A-3 SECOND FLOOR PLAN
- A-4 ROOF PLAN
- A-5 BUILDING ELEVATIONS
- A-6 BUILDING ELEVATIONS
- A-7 WALL SECTIONS
- A-8 WALL SECTIONS
- A-9 WALL SECTION DETAILS
- A-10 STAIR SECTIONS
- A-11 ELEVATOR AND STAIR SECTIONS

PROJECT INFORMATION

PROJECT

STATE BANK OF CROSS PLAINS
CITY "M"
MADISON, WISCONSIN
OWNER

STATE BANK OF CROSS PLAINS
1205 MAIN STREET
CROSS PLAINS WISCONSIN 53562
PHONE (608) 798-7961

GENERAL CONTRACTOR

BUILDING CONSTRUCTION, INC.
P.O. BOX 620151
8005 UNIVERSITY GREEN
MIDDLETON, WISCONSIN 53562
PHONE (608) 831-0011 FAX (608) 831-6817

ENGINEER/ARCHITECT

MAYO CORPORATION
600 GRAND CANYON DRIVE
MADISON, WISCONSIN 53719
PHONE (608) 833-0628 FAX (608) 833-0746

INTERIOR DESIGN CONSULTANT

DEVENISH ASSOCIATES
2111 MONONA DRIVE
MADISON, WISCONSIN 53716
PHONE (608) 223-4055 FAX (608) 223-4058

BUILDING INFORMATION

OCCUPANCY	OFFICE & MERCANTILE BUILDING CHF 54
CLASS OF CONSTRUCTION	TYPE 6 METAL FRAME UNPROTECTED (NON-SPRINKERED)
NUMBER OF FLOORS	2 W/ BASEMENT
BUILDING FLOOR AREAS	BASEMENT FLOOR AREAS FIRST FLOOR AREAS SECOND FLOOR AREAS TOTAL BUILDING FLOOR AREA
TOTAL BUILDING SITE AREA	

NOT FOR CONSTRUCTION

SYMBOLS

ROOM NAME AND NUMBER

ROOM
NAME
NUMBER

'OPENING' REFERENCE NUMBER

100A

PARTITION TYPE REFERENCE

A

BUILDING SECTION REFERENCE

Detail Number
501

WALL SECTION REFERENCE

Detail Number
501

INTERIOR ELEVATION DETAIL

Detail Number
501

WINDOW/IGU TYPE

A

DETAIL SECTION REFERENCE

Detail Number
501

DETAIL PLAN REFERENCE

Detail Number
501
Page Number


MATERIALS

SECTION

- EARTH
- GRANULAR FILL
- CONCRETE, POURED
- CONCRETE MASONRY UNIT
- BRICK
- METAL

ELEVATION

- CONCRETE, EIFS
- SHEET METAL (LARGE SCALE)
- BRICK
- VINYL SIDING
- WOOD (ROUGH)
- WOOD (FINISHED)
- PLYWOOD
- INSULATION (BATT)
- INSULATION (RIGID)
- CARPET

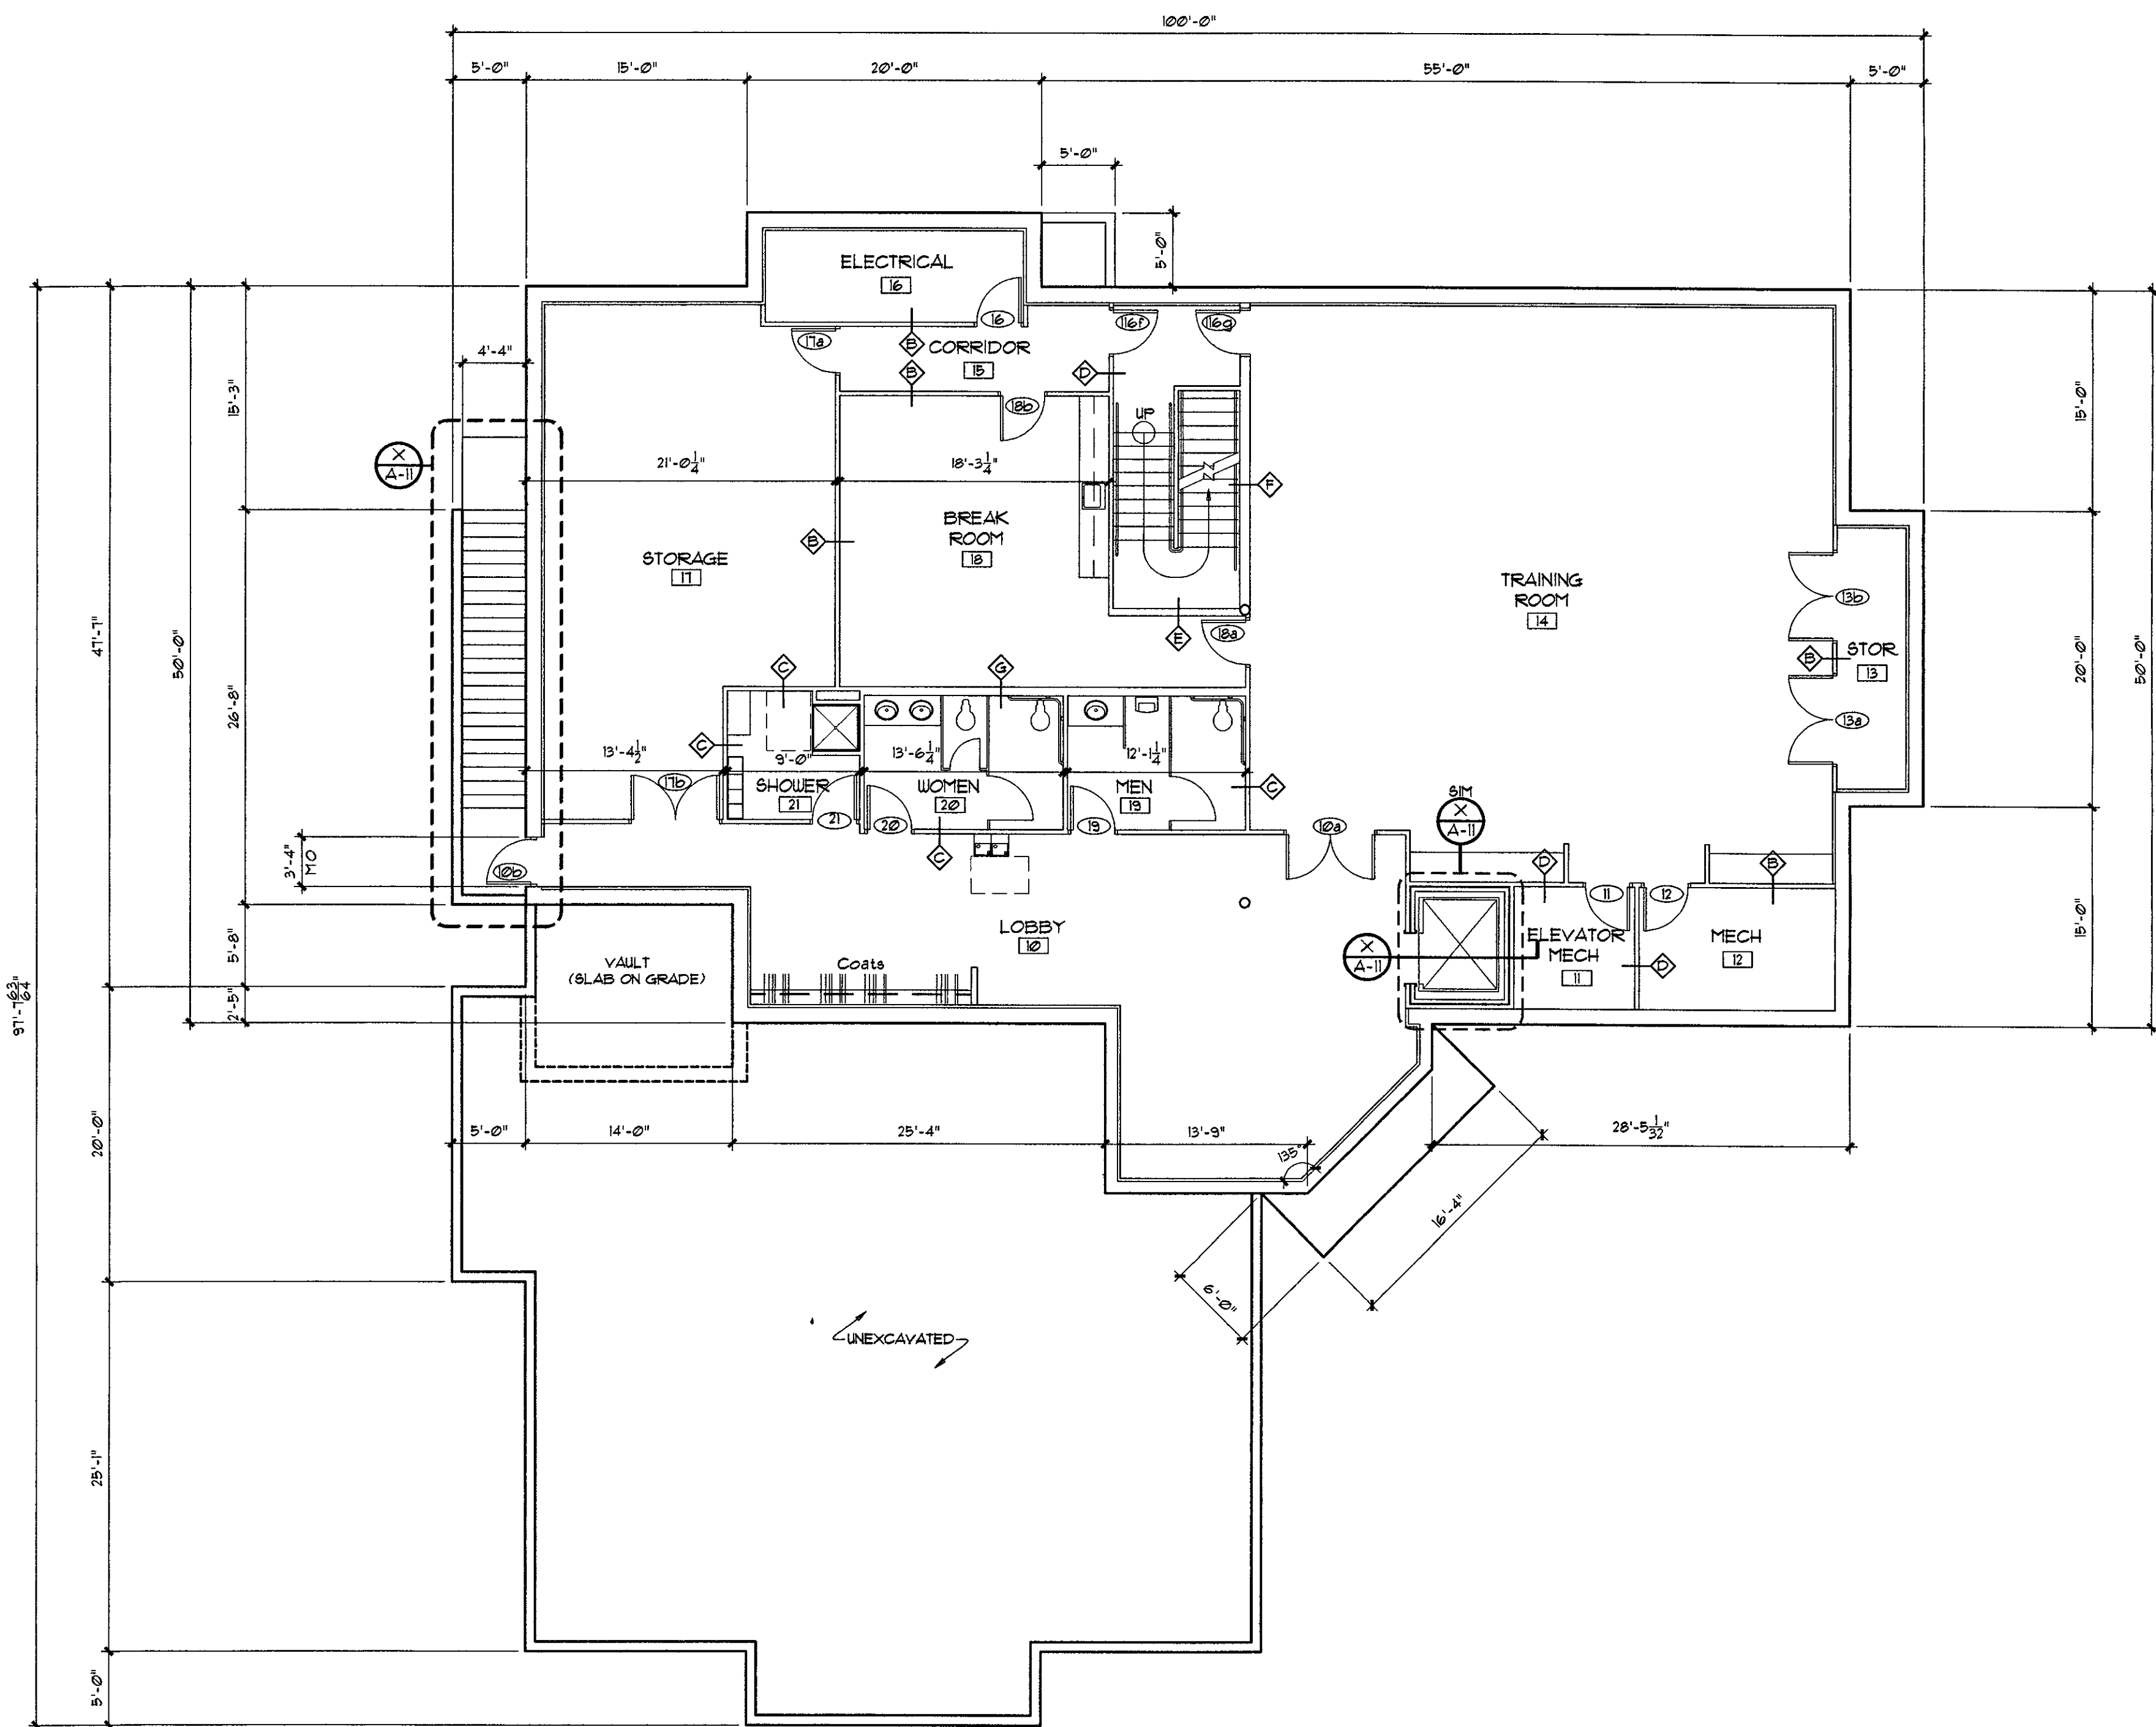

OWNER: STATE BANK OF CROSS PLAINS
 PROJECT: STATE BANK OF CROSS PLAINS
 COUNTY: HUNTER TWP
 MADISON, WISCONSIN

BASEMENT FLOOR PLAN 4,801 sq ft
 SCALE 1/8" = 1'-0"

PROJECT NORTH TRUE NORTH



NOT FOR CONSTRUCTION

MAYO corporation
 ENGINEERS SURVEYORS ARCHITECTS PLANNERS
 600 GRAND CANYON DRIVE, MADISON, WI 53719-1044
 PHONE (608) 833-0628 FAX (608) 833-0746
 E-MAIL MAYOCO@MAYOENGRS.COM

ABC
 BUILDING CONSTRUCTION INC.
 P O BOX 620151
 MIDDLETON, WI 53562-0151
 (608) 831-0011
 FAX (608) 836-6811

OWNER: STATE BANK OF CROSS PLAINS
 PROJECT: STATE BANK OF CROSS PLAINS
 COUNTY: HUNTER TWP
 MADISON, WISCONSIN

INITIALS
FILE
10-20-00
SCALE AS SHOWN
BI-03-00
SHEET NO.
A = 1

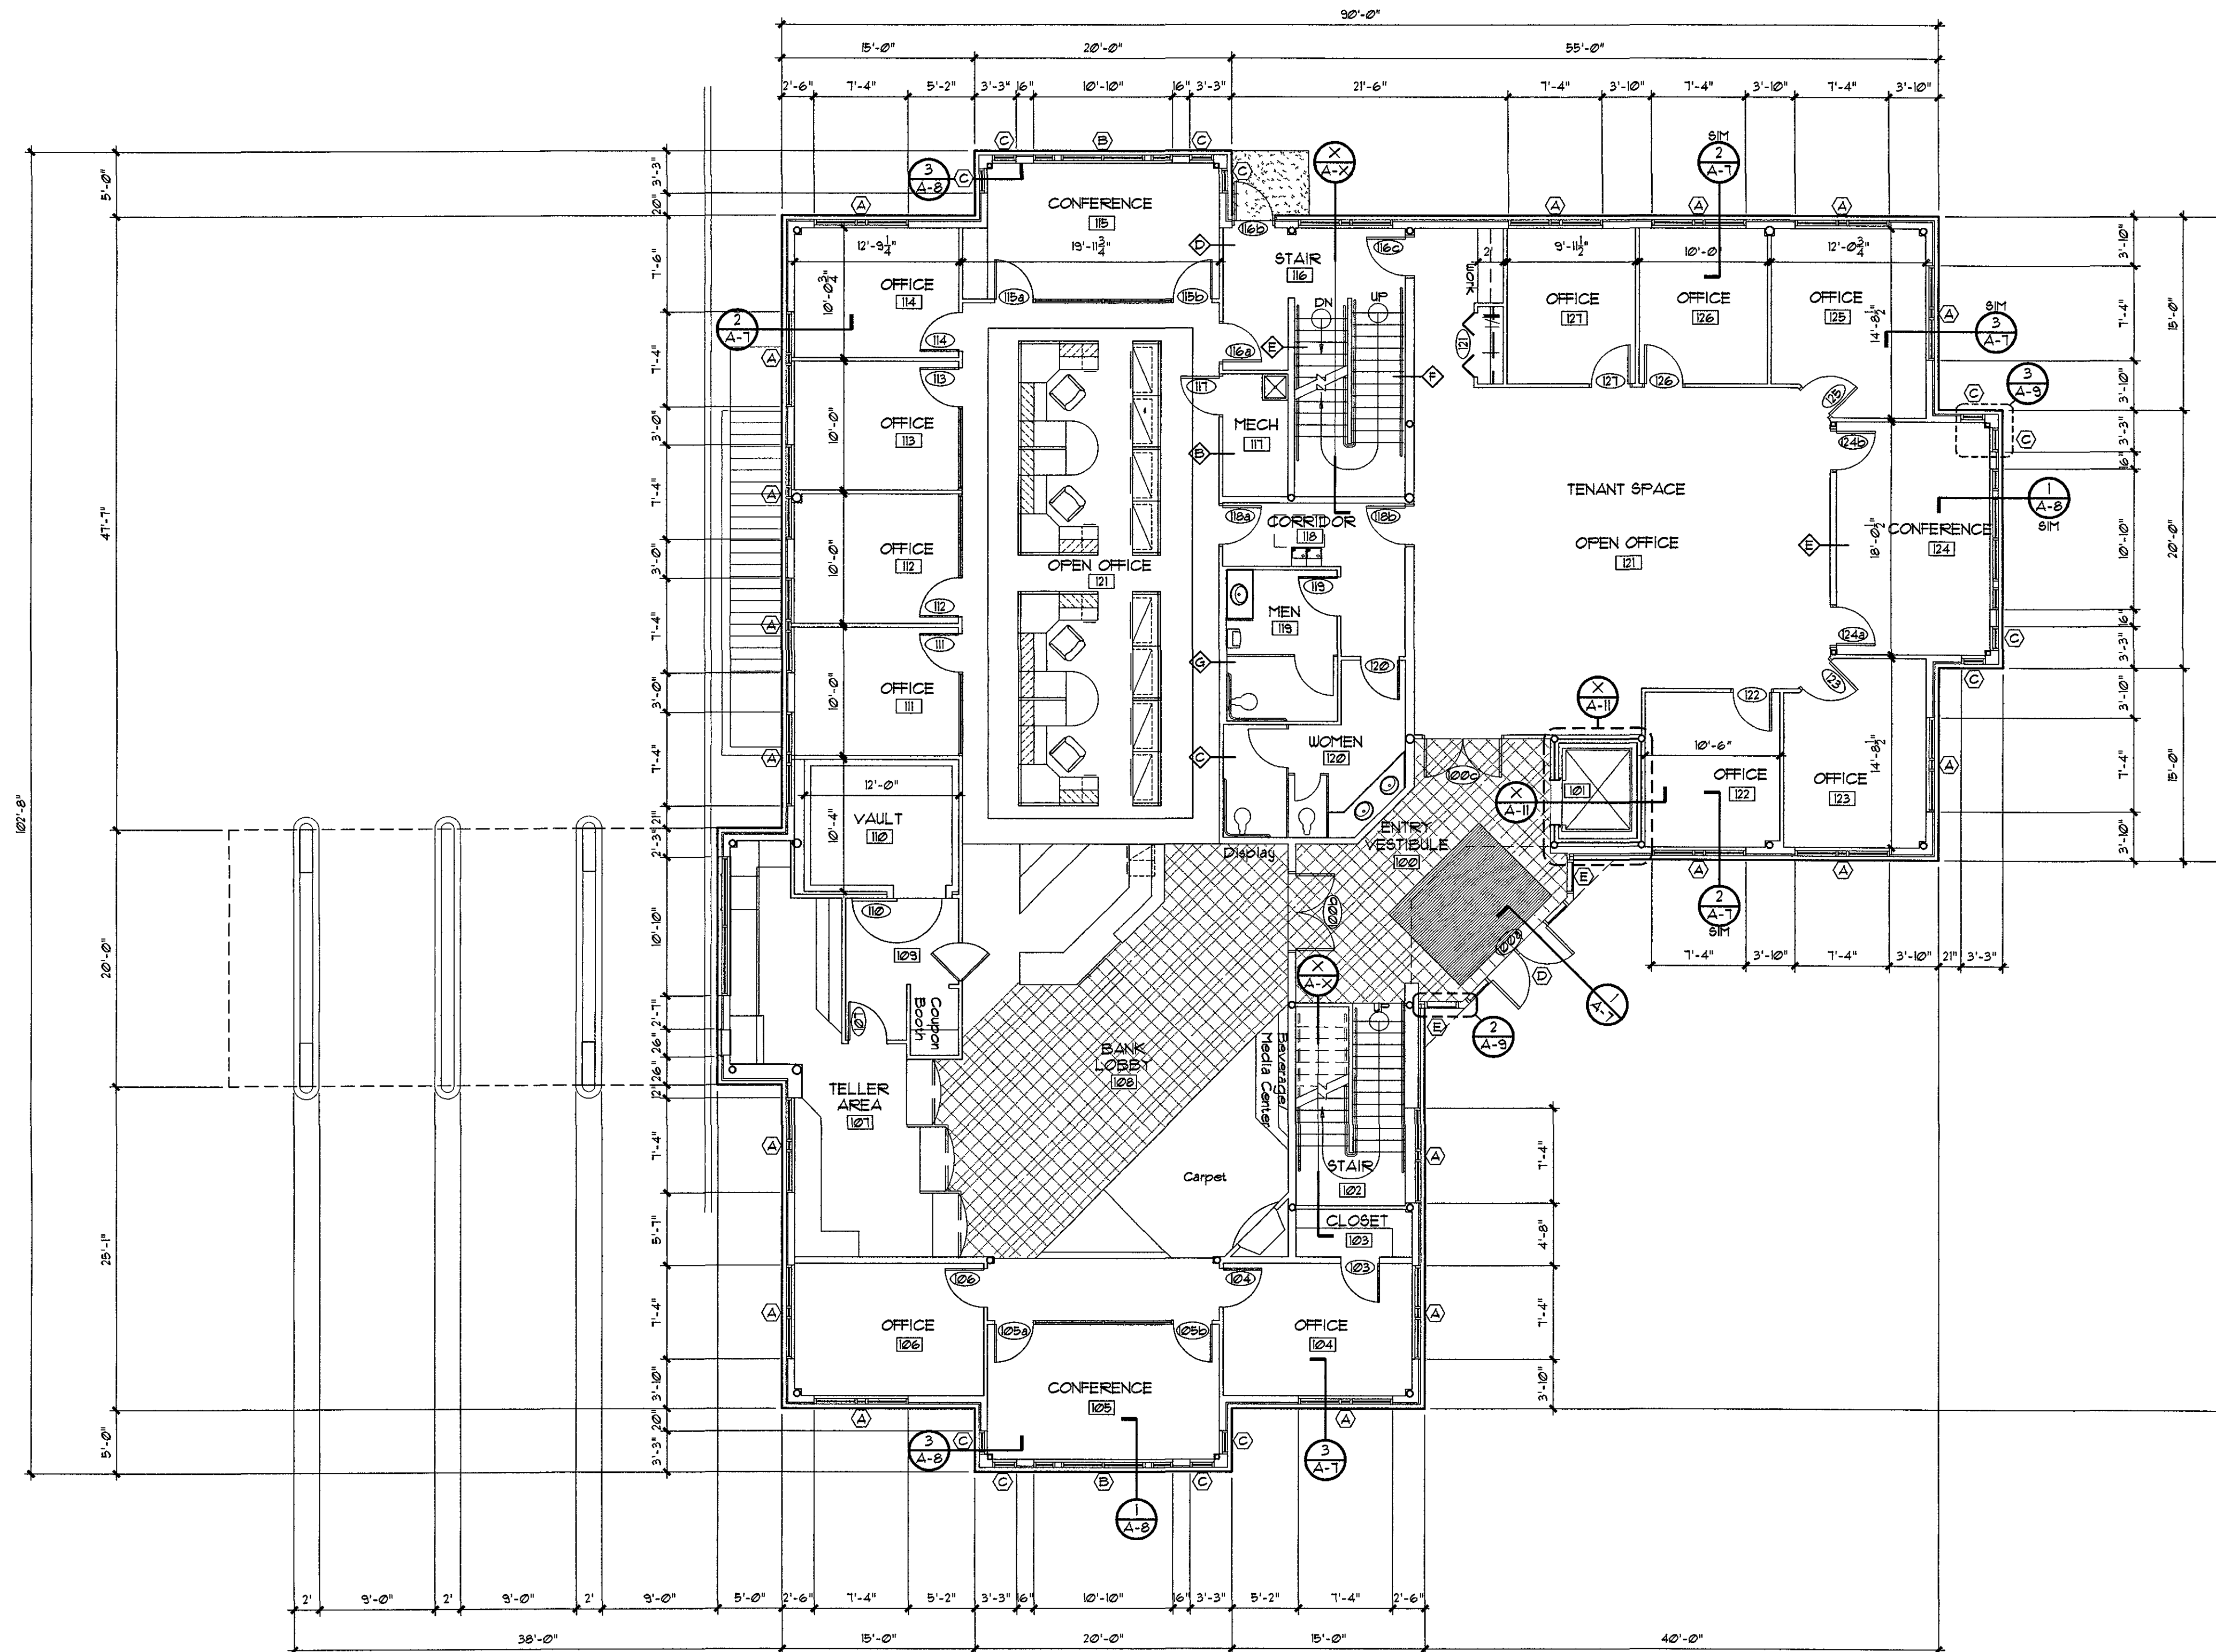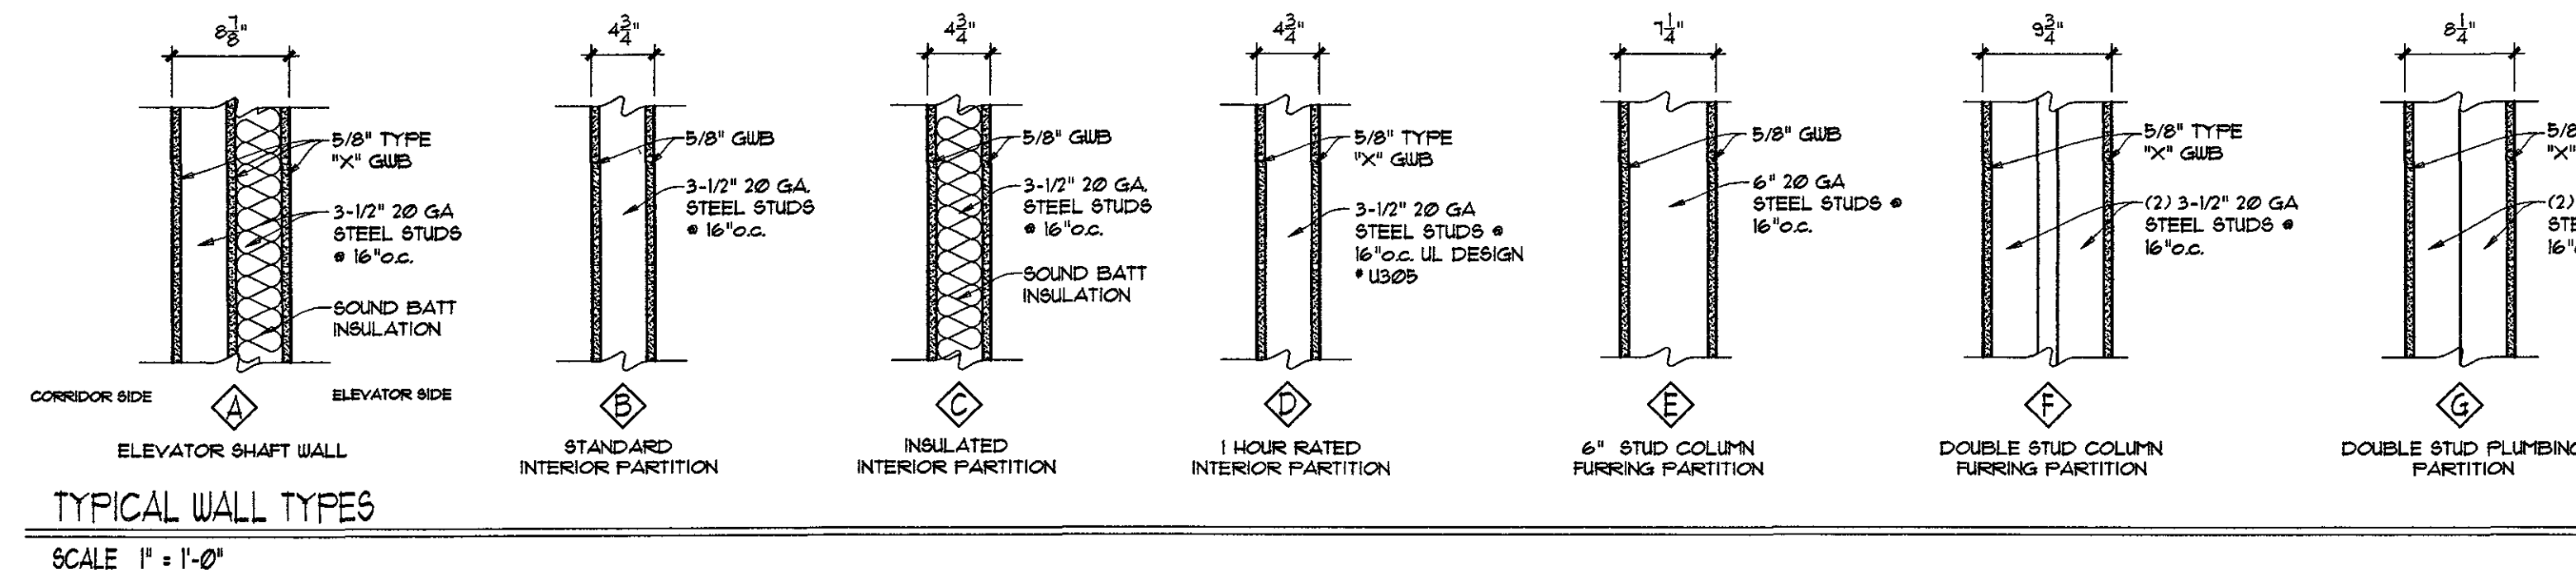

PROJECT NORTH TRUE NORTH
FIRST FLOOR PLAN 1123 sq ft
SCALE 1/8" = 1'-0"

BUILDING CONSTRUCTION INC.

OWNER
STATE BANK OF CROSS PLAINS
PROJECT
STATE BANK OF CROSS PLAINS
COUNTY HWY 141
MADISON, WISCONSIN



INITIALS
FILE
10-13-00
SCALE AS SHOWN
B1-03-00
SHEET NO.

A = 2

BUILDING CONSTRUCTION INC.
P O BOX 620151
MIDDLETON, WI 53562-0151
(608) 831-0011
FAX (608) 836-6811

MAYO Corporation
ENGINEERS SURVEYORS ARCHITECTS PLANNERS
600 GRAND CANYON DRIVE, MADISON, WI 53719-1044
PHONE (608) 833-0628 FAX (608) 833-0746
E-MAIL MAYO@MAYOENGRS.COM

Madison

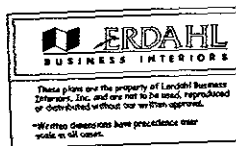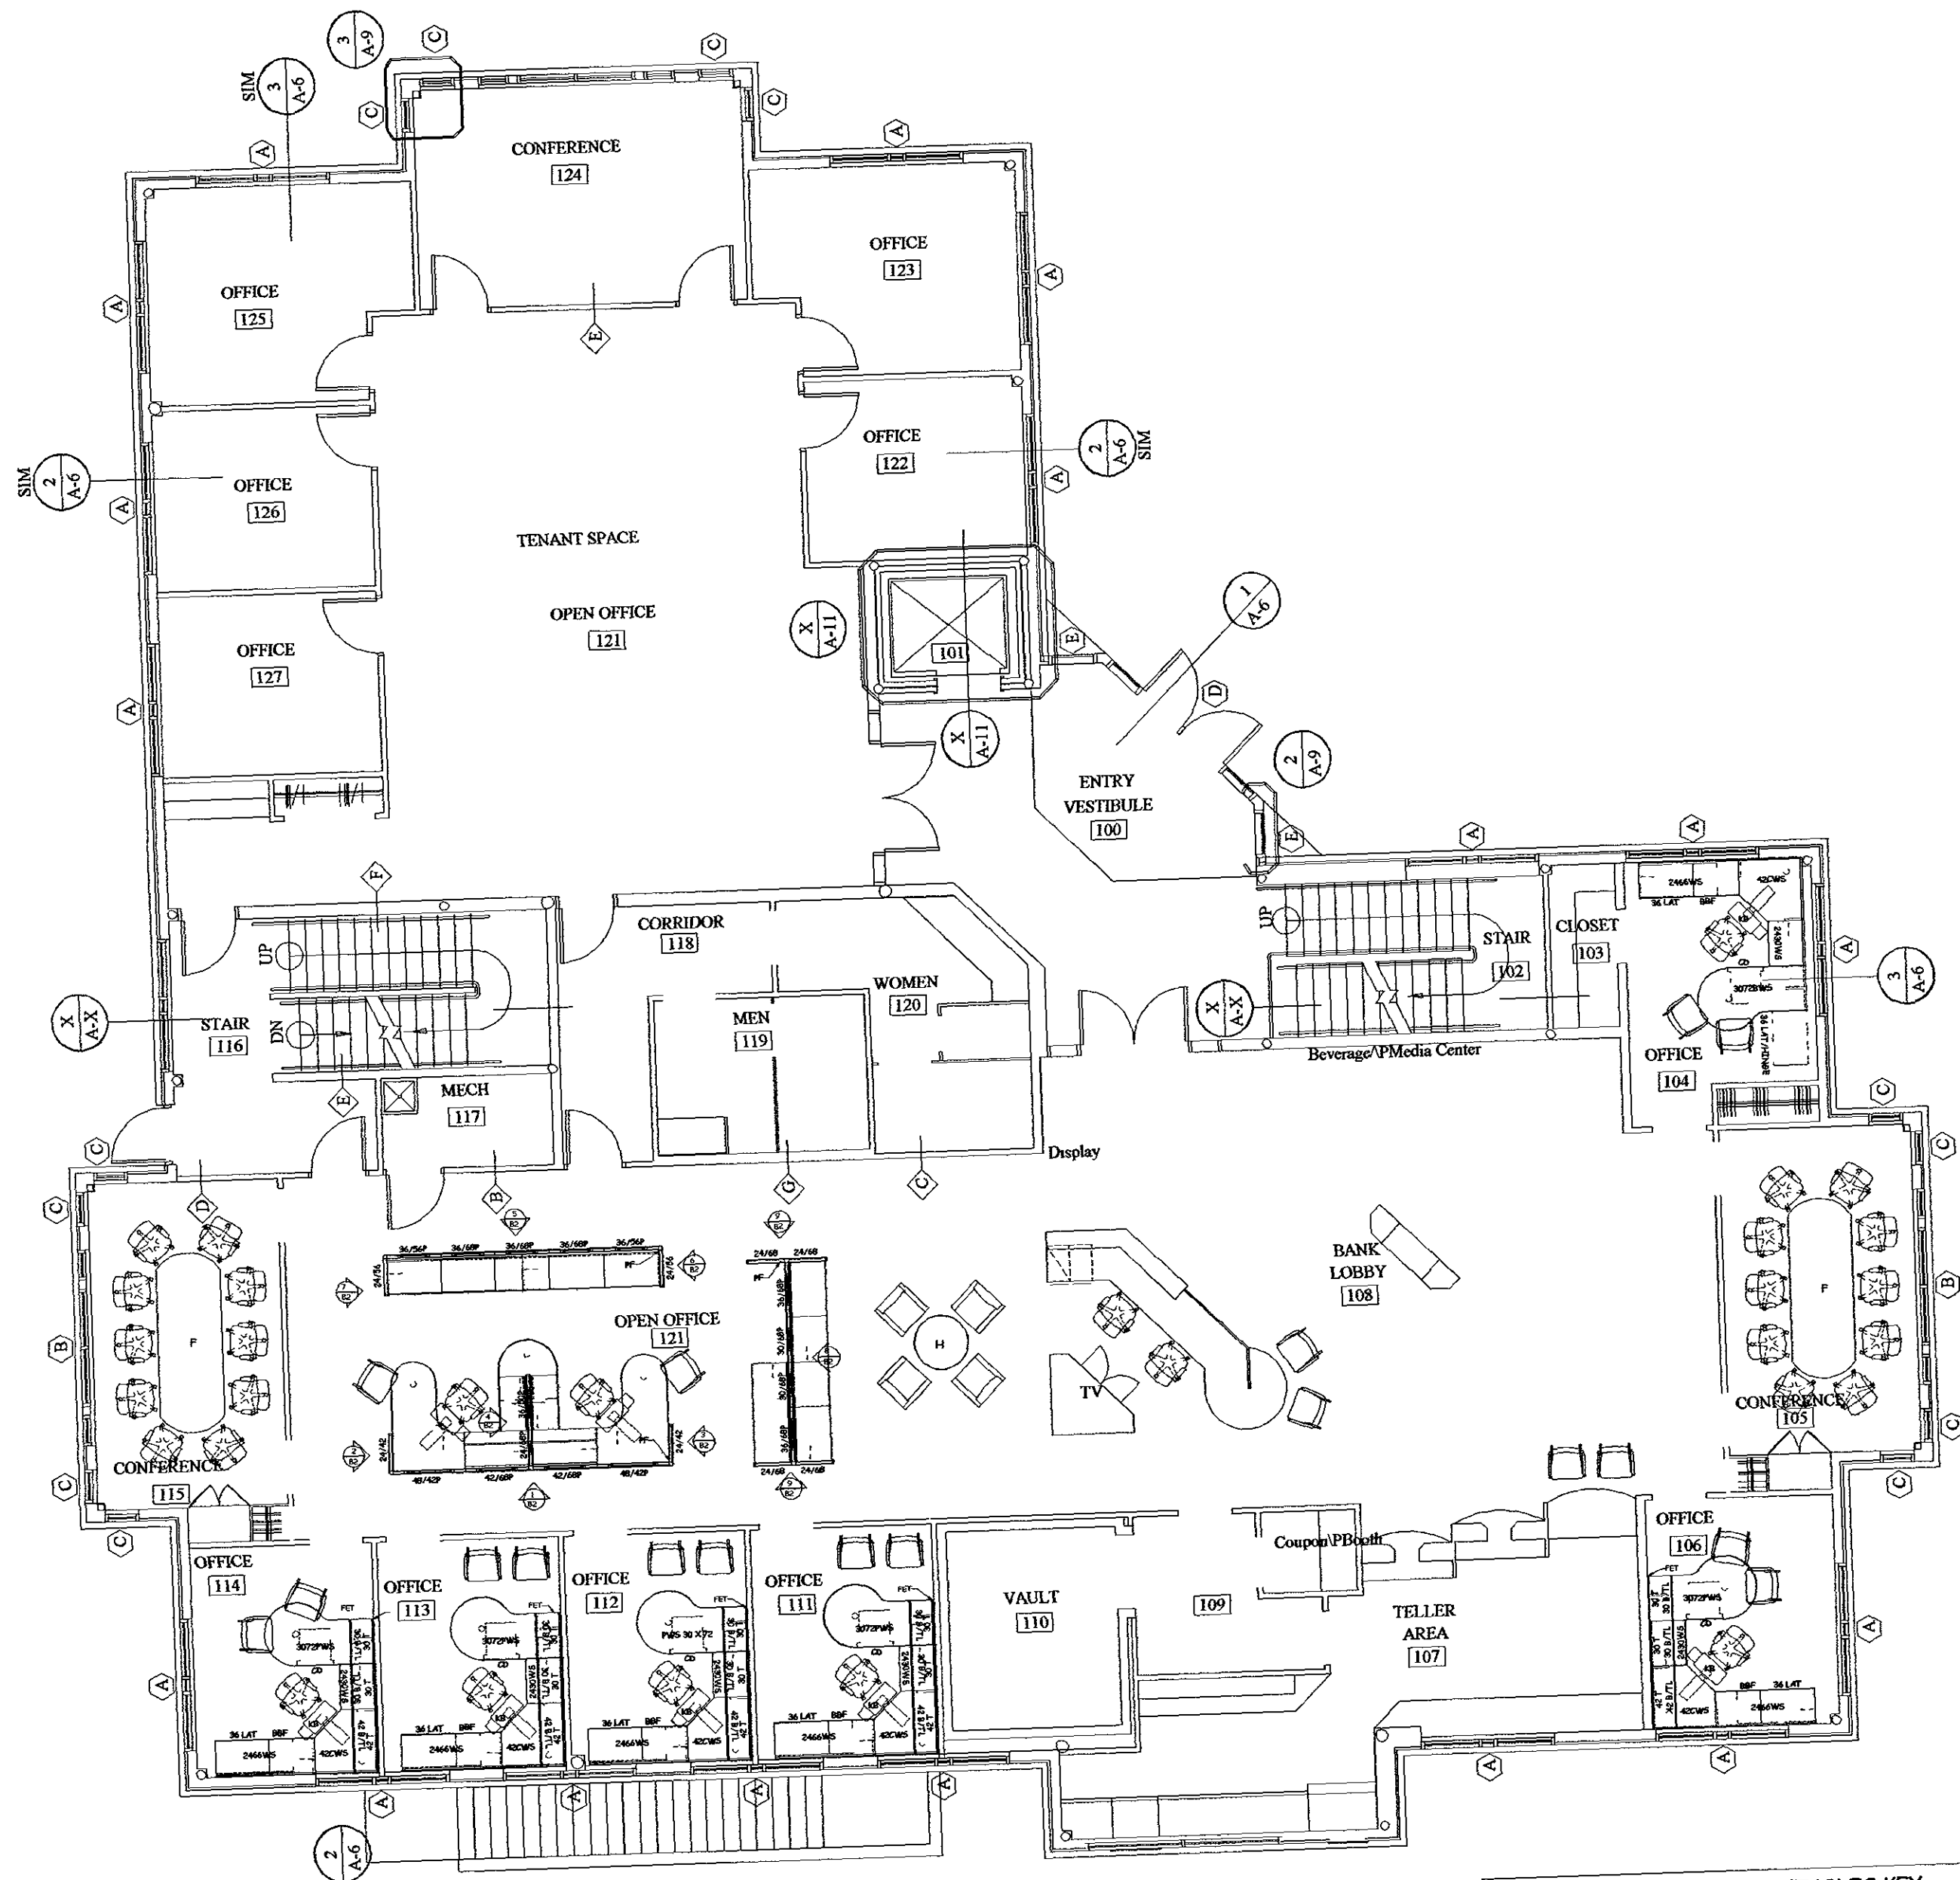

STATE BANK OF CROSS PLAINS

100% ALLOCATION


100% ALLOCATION

100% ALLOCATION

INSTALL PANEL/TRAXX/TABLES KEY

36/68 SECTIONAL PANEL WIDTH X HEIGHT
P POWERED PANEL
PF POWER FEED
T TRAXX TACK TILE
PET FULL END TRIM

NOTES
1. ALL PANELS ARE FABRIC COVERED UNLESS NOTED OTHERWISE
SEE ATTACHED ELEVATION DRAWINGS FOR SECTIONAL PANELS
2. PROVIDE (1) DUPLEX OUTLET PER "POWERED" PANEL UNLESS
SHARED BY ANOTHER STATION THEN PROVIDE A MINIMUM
OF (1) DUPLEX OUTLET ON EACH SIDE OF THE "POWERED"
PANEL (2) FOR 60" WIDE PANELS
3. ALL PANEL TRIM IS SOFTENED

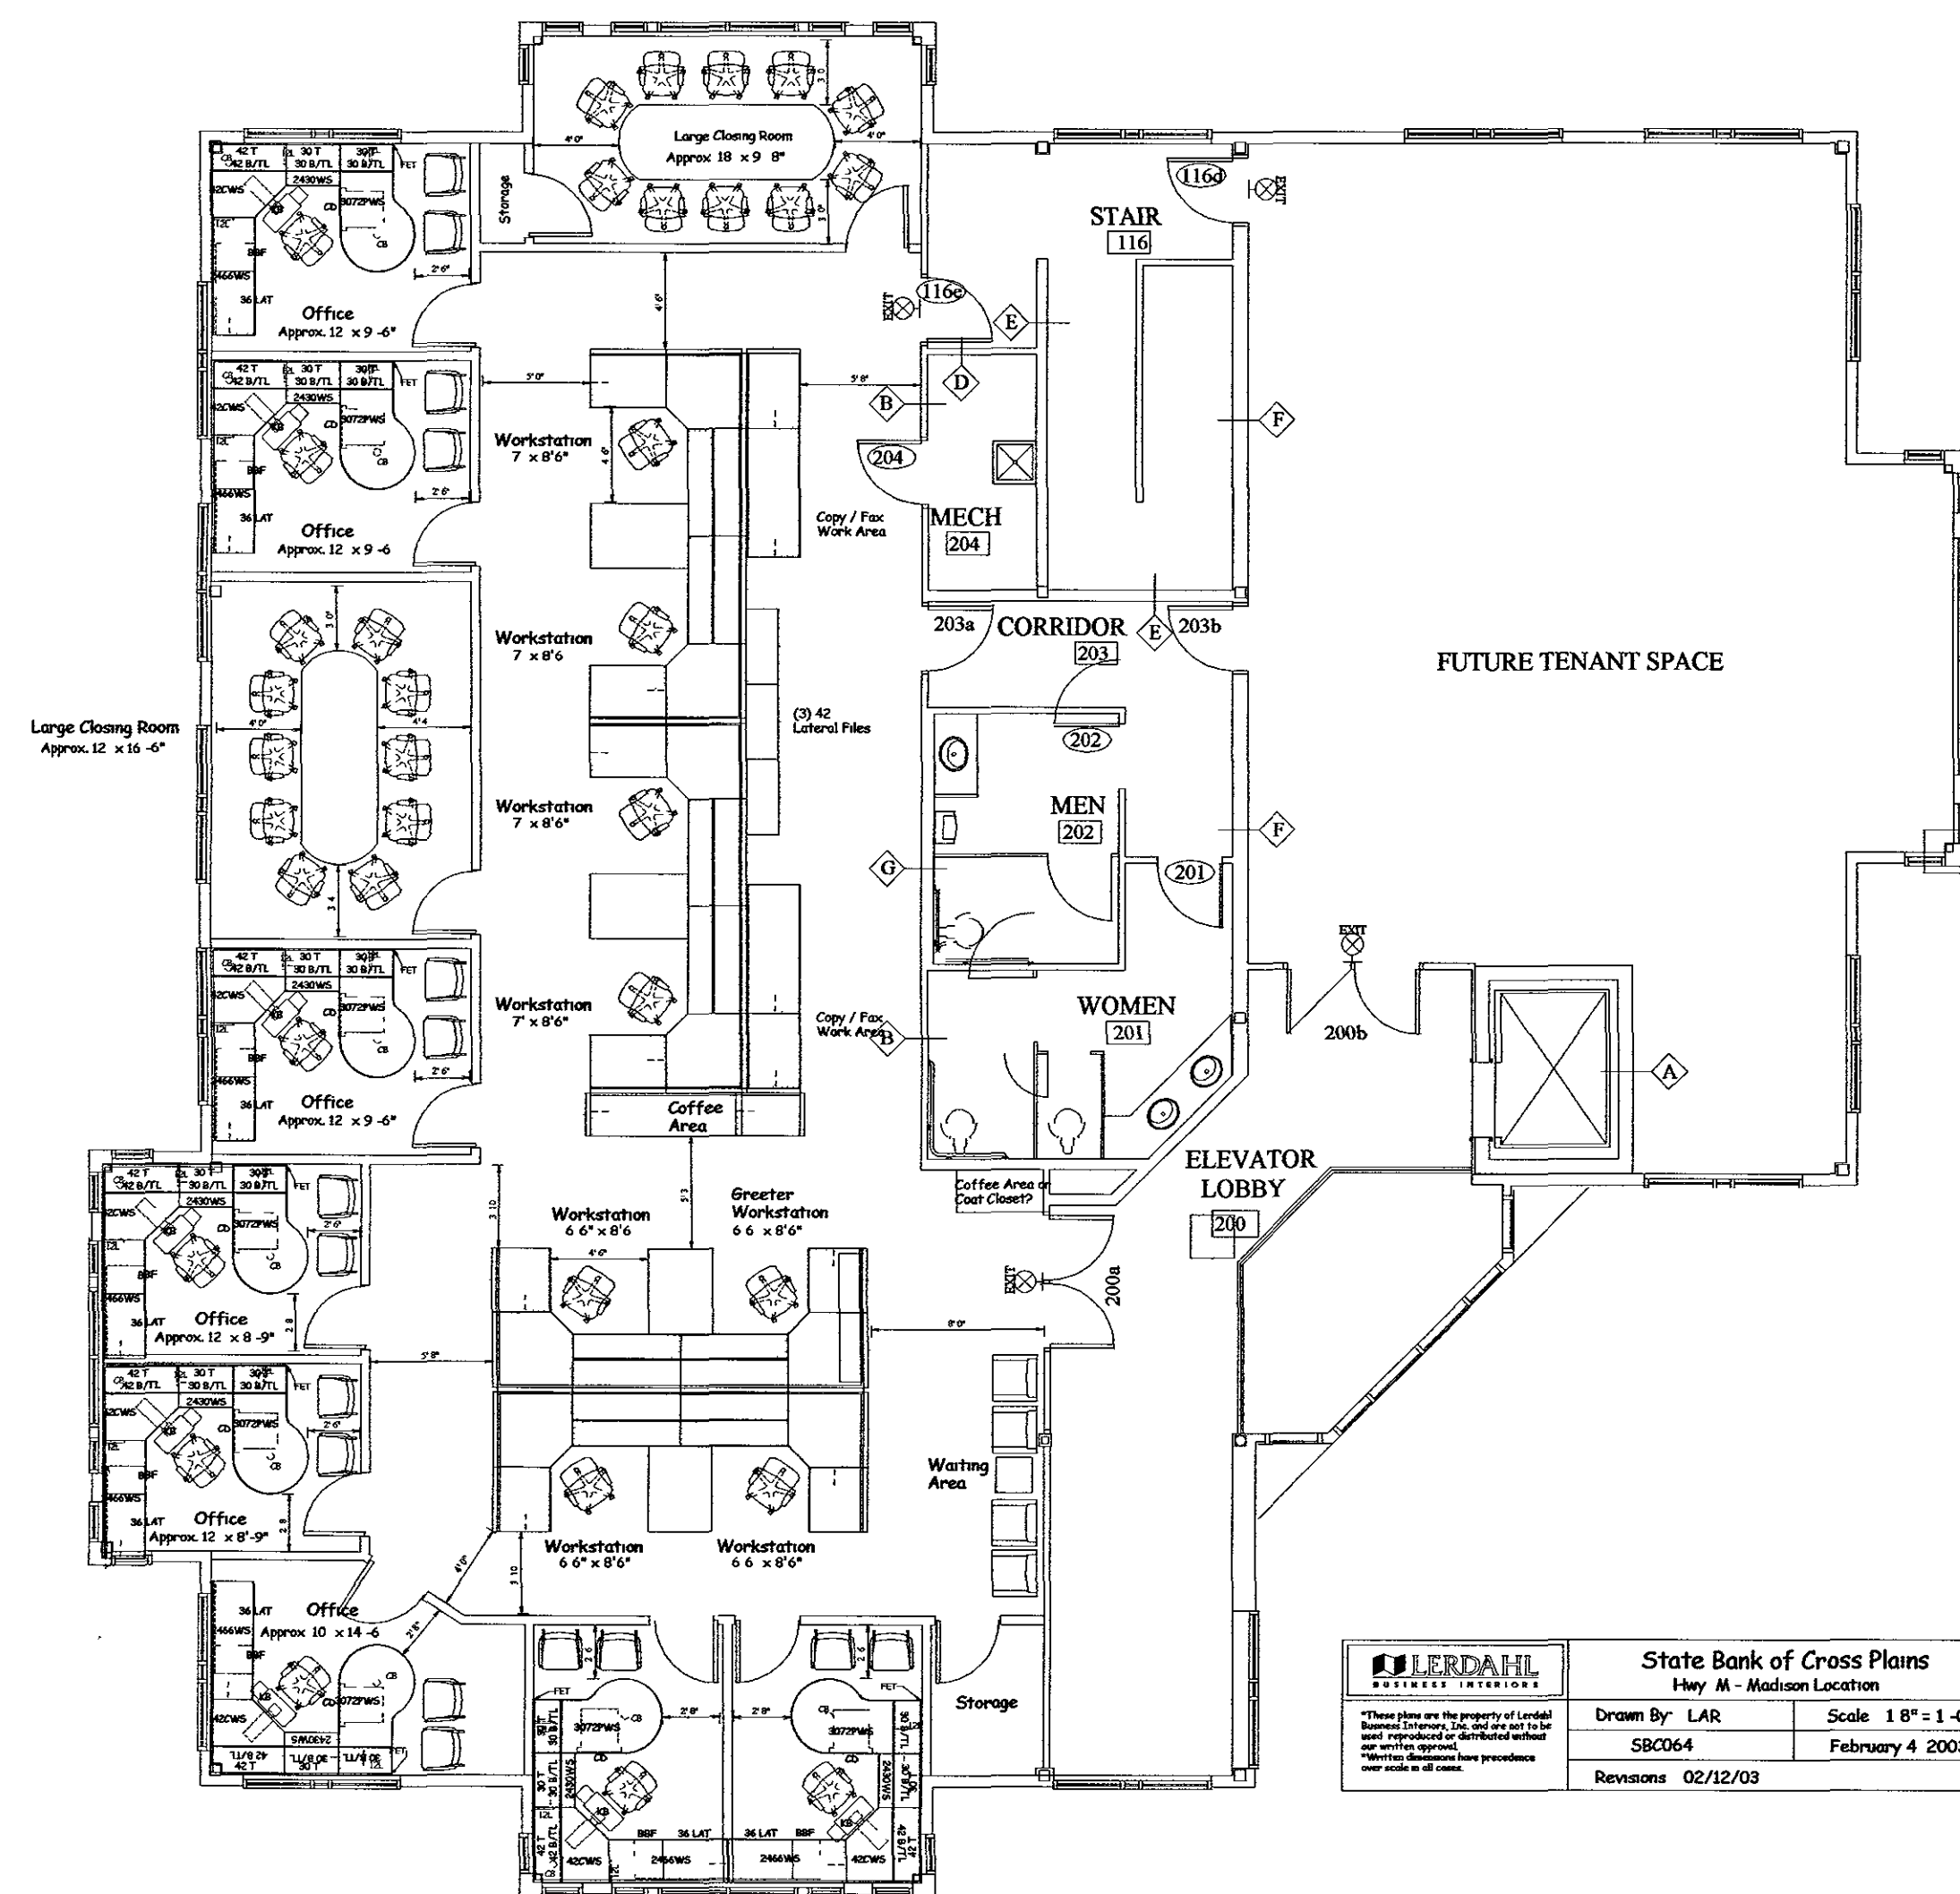

 These plans are the property of Lerdahl Business Interiors. The use and reproduction of these plans without express reproduction or derivative without express written permission is prohibited. *Merits decisions have precedence over serials in all cases.	State Bank of Cross Plains Hwy M - Madison Location	
	Drawn By LAR 5BC064	Scale 1 8" = 1 -0" February 4 2003
Revisions 02/12/03		