



**ADA COMPLIANT MOUNTING HEIGHTS**  
2018/RECURS DESIGN & CONSTRUCTION INC. DRAWINGS DATE: 6/17/18

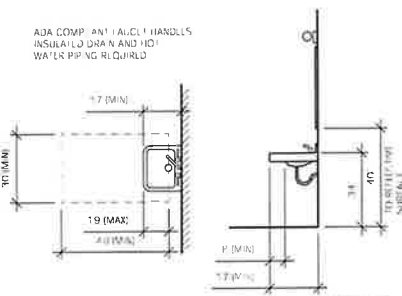

**ADA COMPLIANT LAVATORY ELEVATIONS**  
2018/RECURS DESIGN & CONSTRUCTION INC. DRAWINGS DATE: 6/17/18


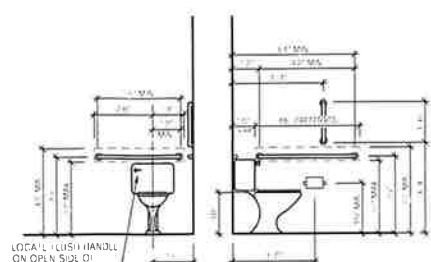


**ADA COMPLIANT TOILET ELEVATIONS**  
2018/RECURS DESIGN & CONSTRUCTION INC. DRAWINGS DATE: 6/17/18


VERIFY ALL CONDITIONS AND DIMENSIONS ON THE JOB AND NOTIFY THE DESIGN ALLIANCE ARCHITECTS, INC. OF ANY DISCREPANCIES PRIOR TO START

**LEGEND**

- N-W DOOR WITH ADA COMPLIANT LEVEL HANDLE
- BLANK WALL
- NEW APPROVED ILLUMINATED EXIT SIGN WITH EMERGENCY LIGHTS AND 90 MIN. MIN. BATTERY BACK-UP TYP.
- APPROVED EMERGENCY LIGHTING WITH 90 MIN. MIN. BATTERY BACK-UP TYP. SEE LIGHTS LIGHTING PLAN SHEET 1.
- PROVIDE FIRE EXTINGUISHERS CONFORM TO REQUIREMENTS WITH LOCAL FIRE INSPECTOR

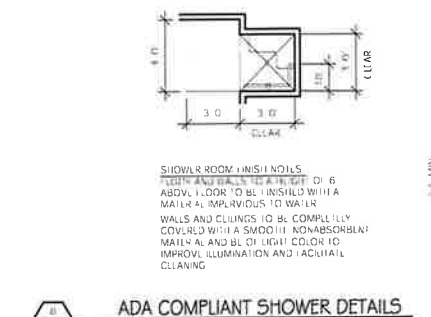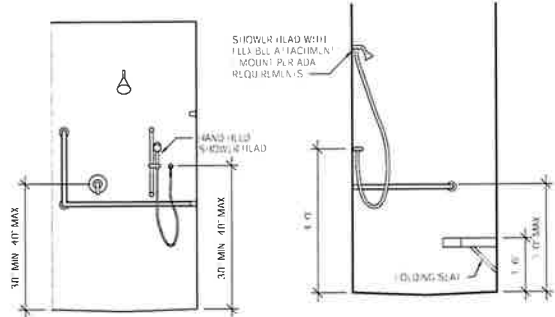


**ADA COMPLIANT SHOWER DETAILS**  
2018/RECURS DESIGN & CONSTRUCTION INC. DRAWINGS DATE: 6/17/18

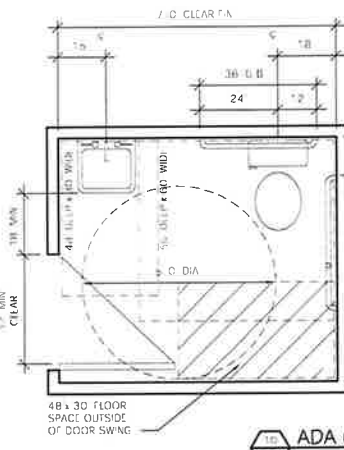

**ADA COMPLIANT BATHROOM PLAN**  
2018/RECURS DESIGN & CONSTRUCTION INC. DRAWINGS DATE: 6/17/18

- CLEAR FLOOR SPACE AT FIXTURES  
30" x 48" AT LAVATORY  
60" DIAMETER TURNING SPACE
- BATHROOM FINISH NOTES  
FLOOR AND WALLS TO BE FINISHED WITH A MATERIAL IMPERVIOUS TO WATER  
WALLS AND CEILING TO BE COMPLETELY COVERED WITH A SMOOTH, NONABSORBENT MATERIAL AND BE OF LIGHT COLOR TO IMPROVE ILLUMINATION AND FACILITATE CLEANING
- PROVIDE 11" G. ACCESSIBLE FAUCETS
- WATER SUPPLY AND DRAIN PIPES UNDER SINK SHALL BE INSULATED TO PREVENT CONDENSATION

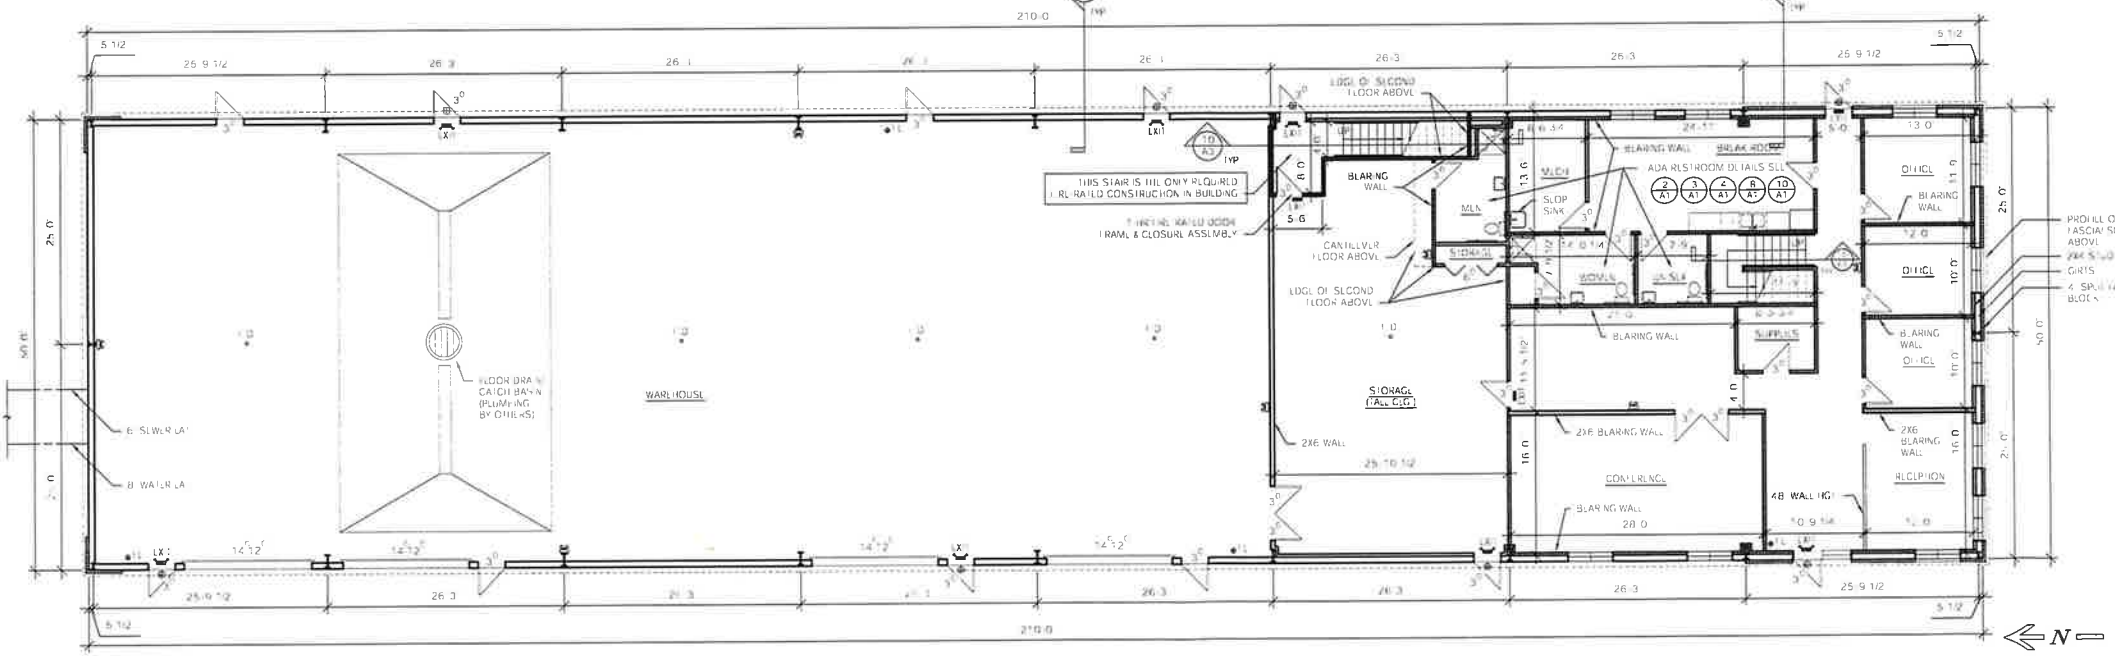

**MAIN FLOOR PLAN**  
2018/RECURS DESIGN & CONSTRUCTION INC. DRAWINGS DATE: 6/17/18

Design Alliance Architects, Inc.  
1003 Madison Avenue  
Port Allen, WI  
(920) 585-3004

**RC GROUP BUILDING B**  
6140 Cottonwood Drive  
Fitchburg, WI, 53719

| DRAWING NAMES        |
|----------------------|
| MAIN FLOOR PLAN      |
| ADA BATHROOM DETAILS |
| LEGEND               |
|                      |
|                      |
|                      |
|                      |
|                      |
|                      |
|                      |
|                      |
| REVISIONS            |
|                      |
|                      |
|                      |
|                      |
|                      |
|                      |
| PROJECT DATA         |
| DATE: 8/30/18        |
| DRAWN BY: JK         |
| CHECKED BY: P.W.     |
| SHEET NO.            |
| <b>A-1</b>           |